

SCRIP PROPOSED OFFICE
J. TOPACIO STREET COR. C.M. RECTO HI-WAY
CLARK FREEPORT ZONE PAMPANGA





VIEW FROM MEETING ROOM




VIEW FROM PM'S OFFICE



VIEW FROM WORK'S STATION

A handwritten signature in blue ink, located in the bottom right corner of the page. The signature is stylized and appears to be a cursive name.

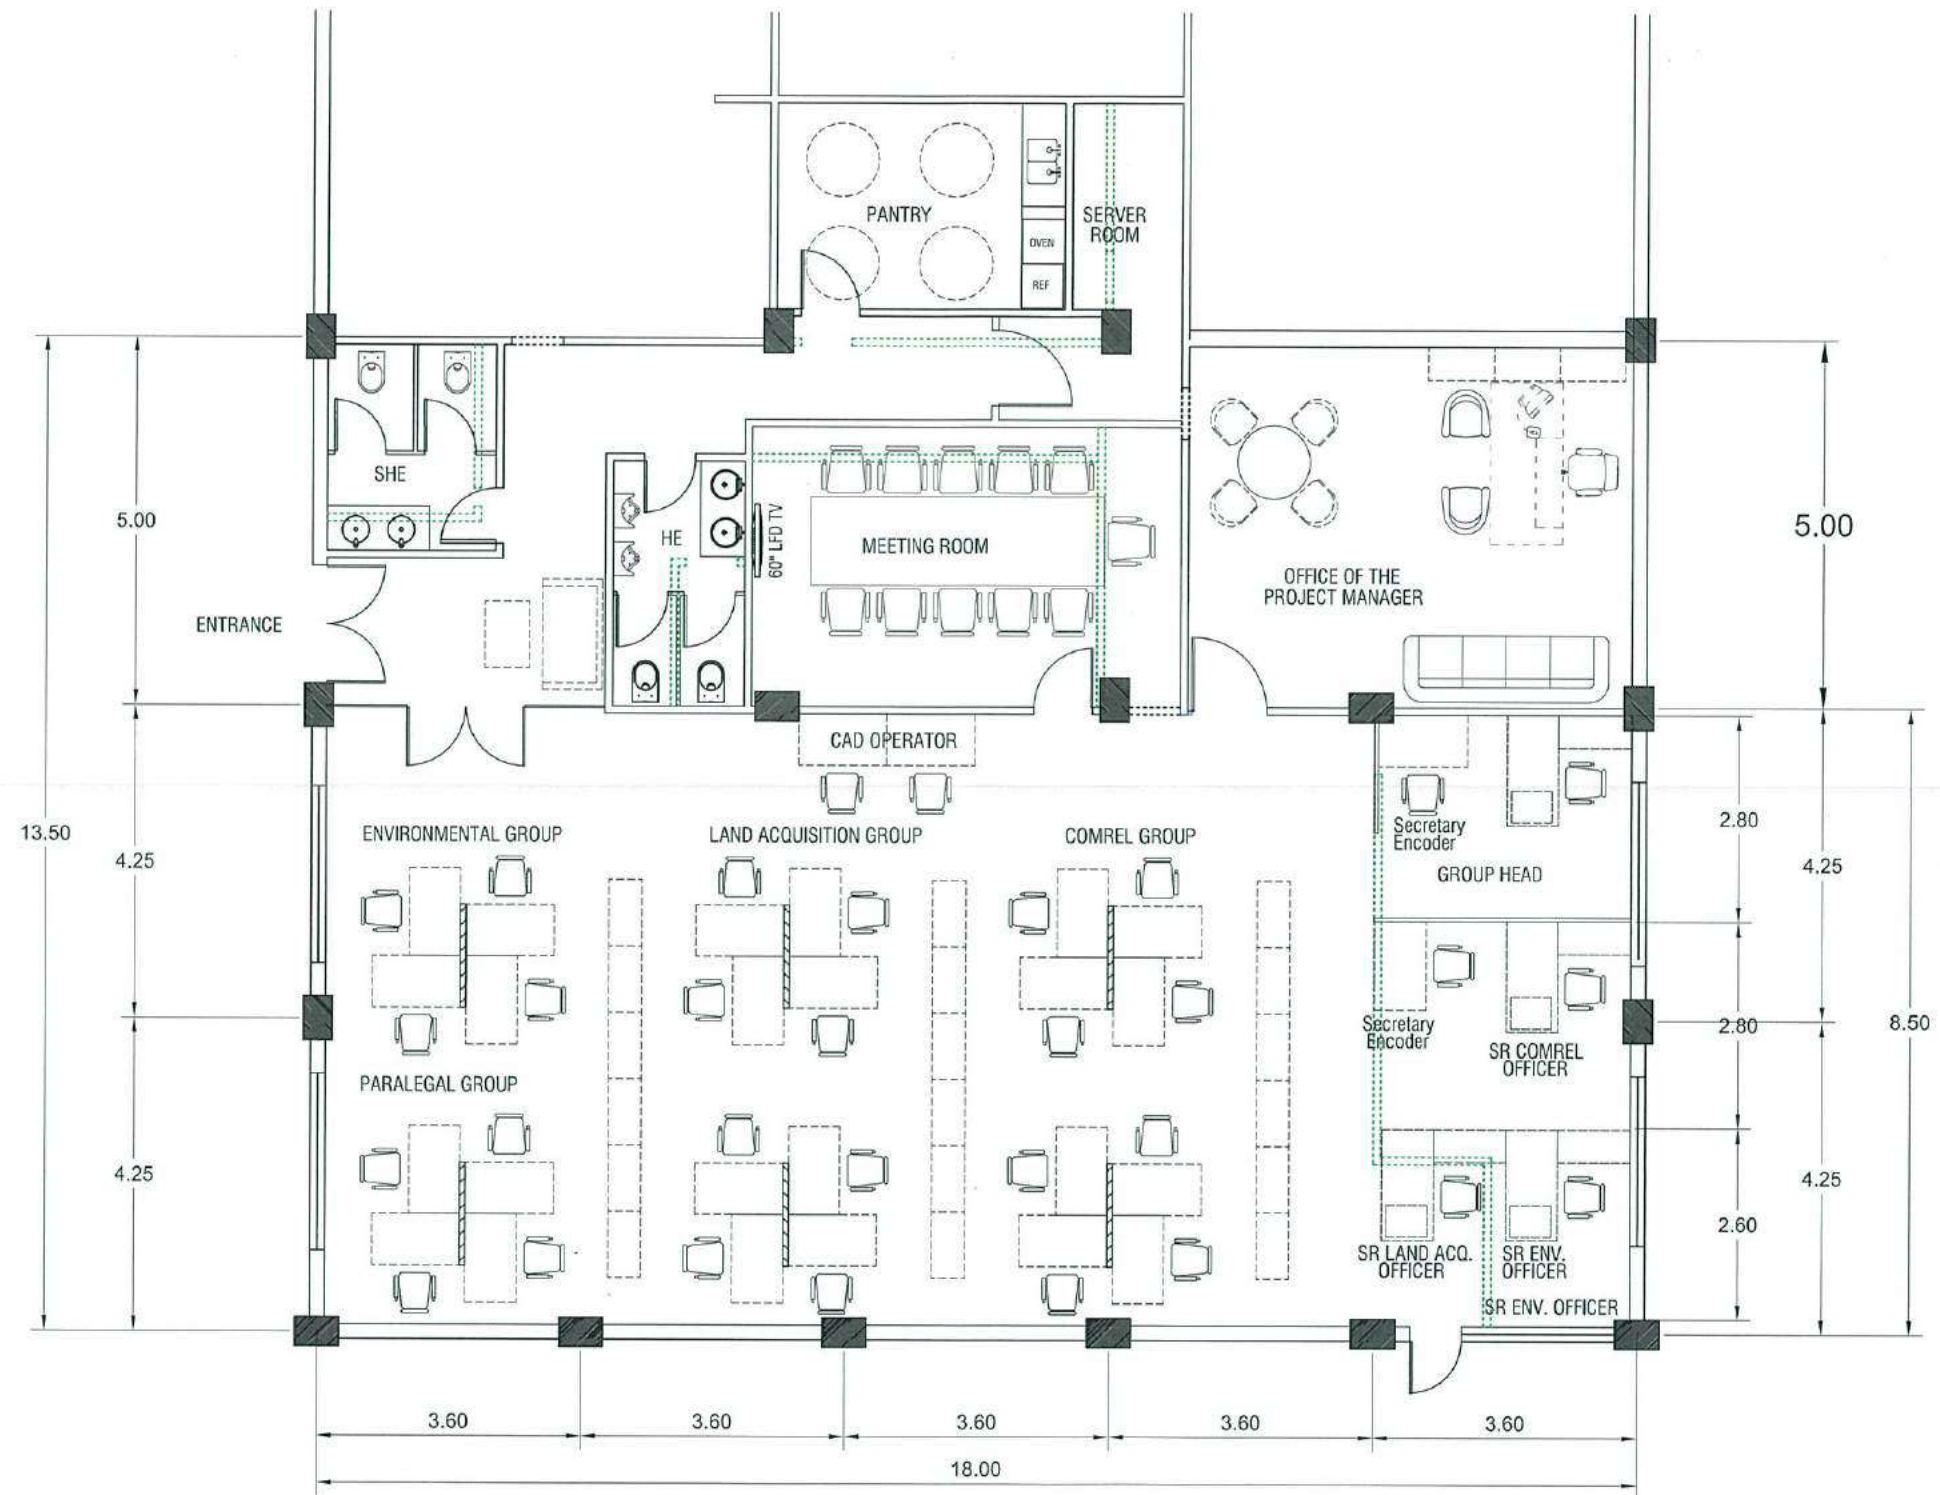

--- WALL TO BE DEMOLISHED



PROJECT NAME
 PROPOSED SCRP OFFICE
 CLARK FREE PORT ZONE, PAMPANGA

PREPARED BY
 AR. JUDENE G. LAGOY
 ARCHITECT, NCC PMO
 AR. ALBERT O. REYES
 CAD OPERATOR, SCRP


CHECKED & REVIEWED BY
 REY S. LIM
 PROJECT MANAGER, SCRP

RECOMMENDING APPROVAL
 AILEEN ANUNCIACION R. ZOSA
 EXECUTIVE VICE PRESIDENT

APPROVED BY
 VIVENCIO B. DIZON
 PRESIDENT AND CEO

SHEET CONTENT
 GENERAL FLOOR PLAN
 SCALE 1 : 100 M. DATE : 08-02-2020


SHEET NO.
 A
 01

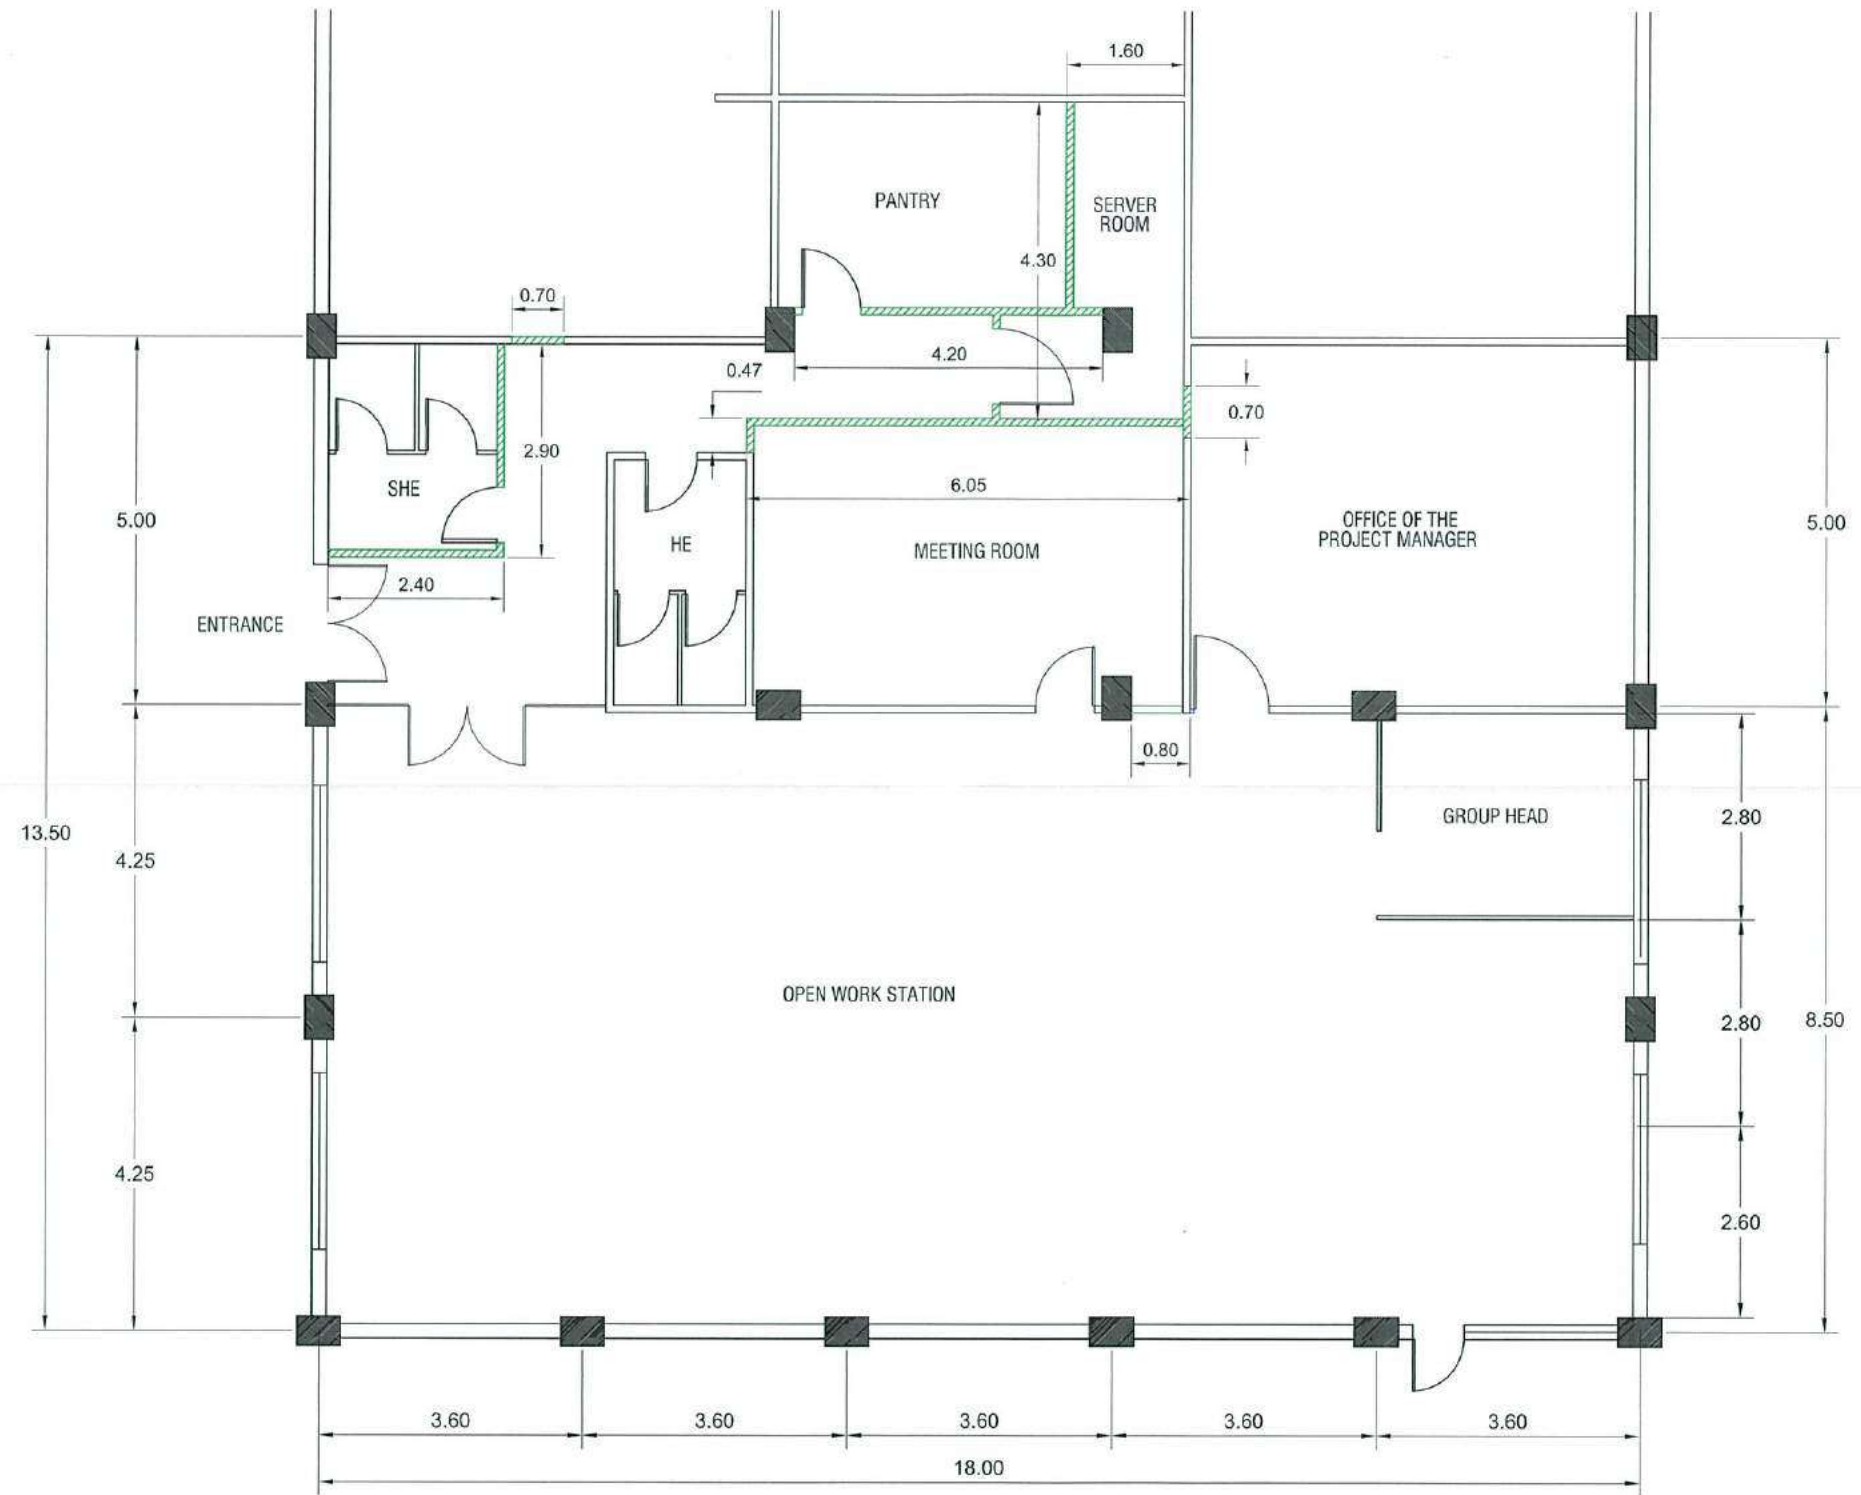

NOTE: 16mm THK FICEM BOARD WITH INSULATION (1 HOUR Rating)
 A=111.90 m²




PROJECT NAME PROPOSED SCRIP OFFICE CLARK FREE PORT ZONE, PAMPANGA	PREPARED BY AR. JUDENE G. LAGOY ARCHITECT, NCC/PMO AR. ALBERT G. REYES CAD OPERATOR, SCRIP	CHECKED & REVIEWED BY REY S. LIM PROJECT MANAGER, SCRIP	RECOMMENDING APPROVAL AILEEN ANUNCIACION R. ROSA EXECUTIVE VICE PRESIDENT	APPROVED BY VIVENCIO B. DIZON PRESIDENT AND CEO	SHEET CONTENT		SHEET NO. A 02
					SCALE 1:100 M.	DATE: 06-02-2020	

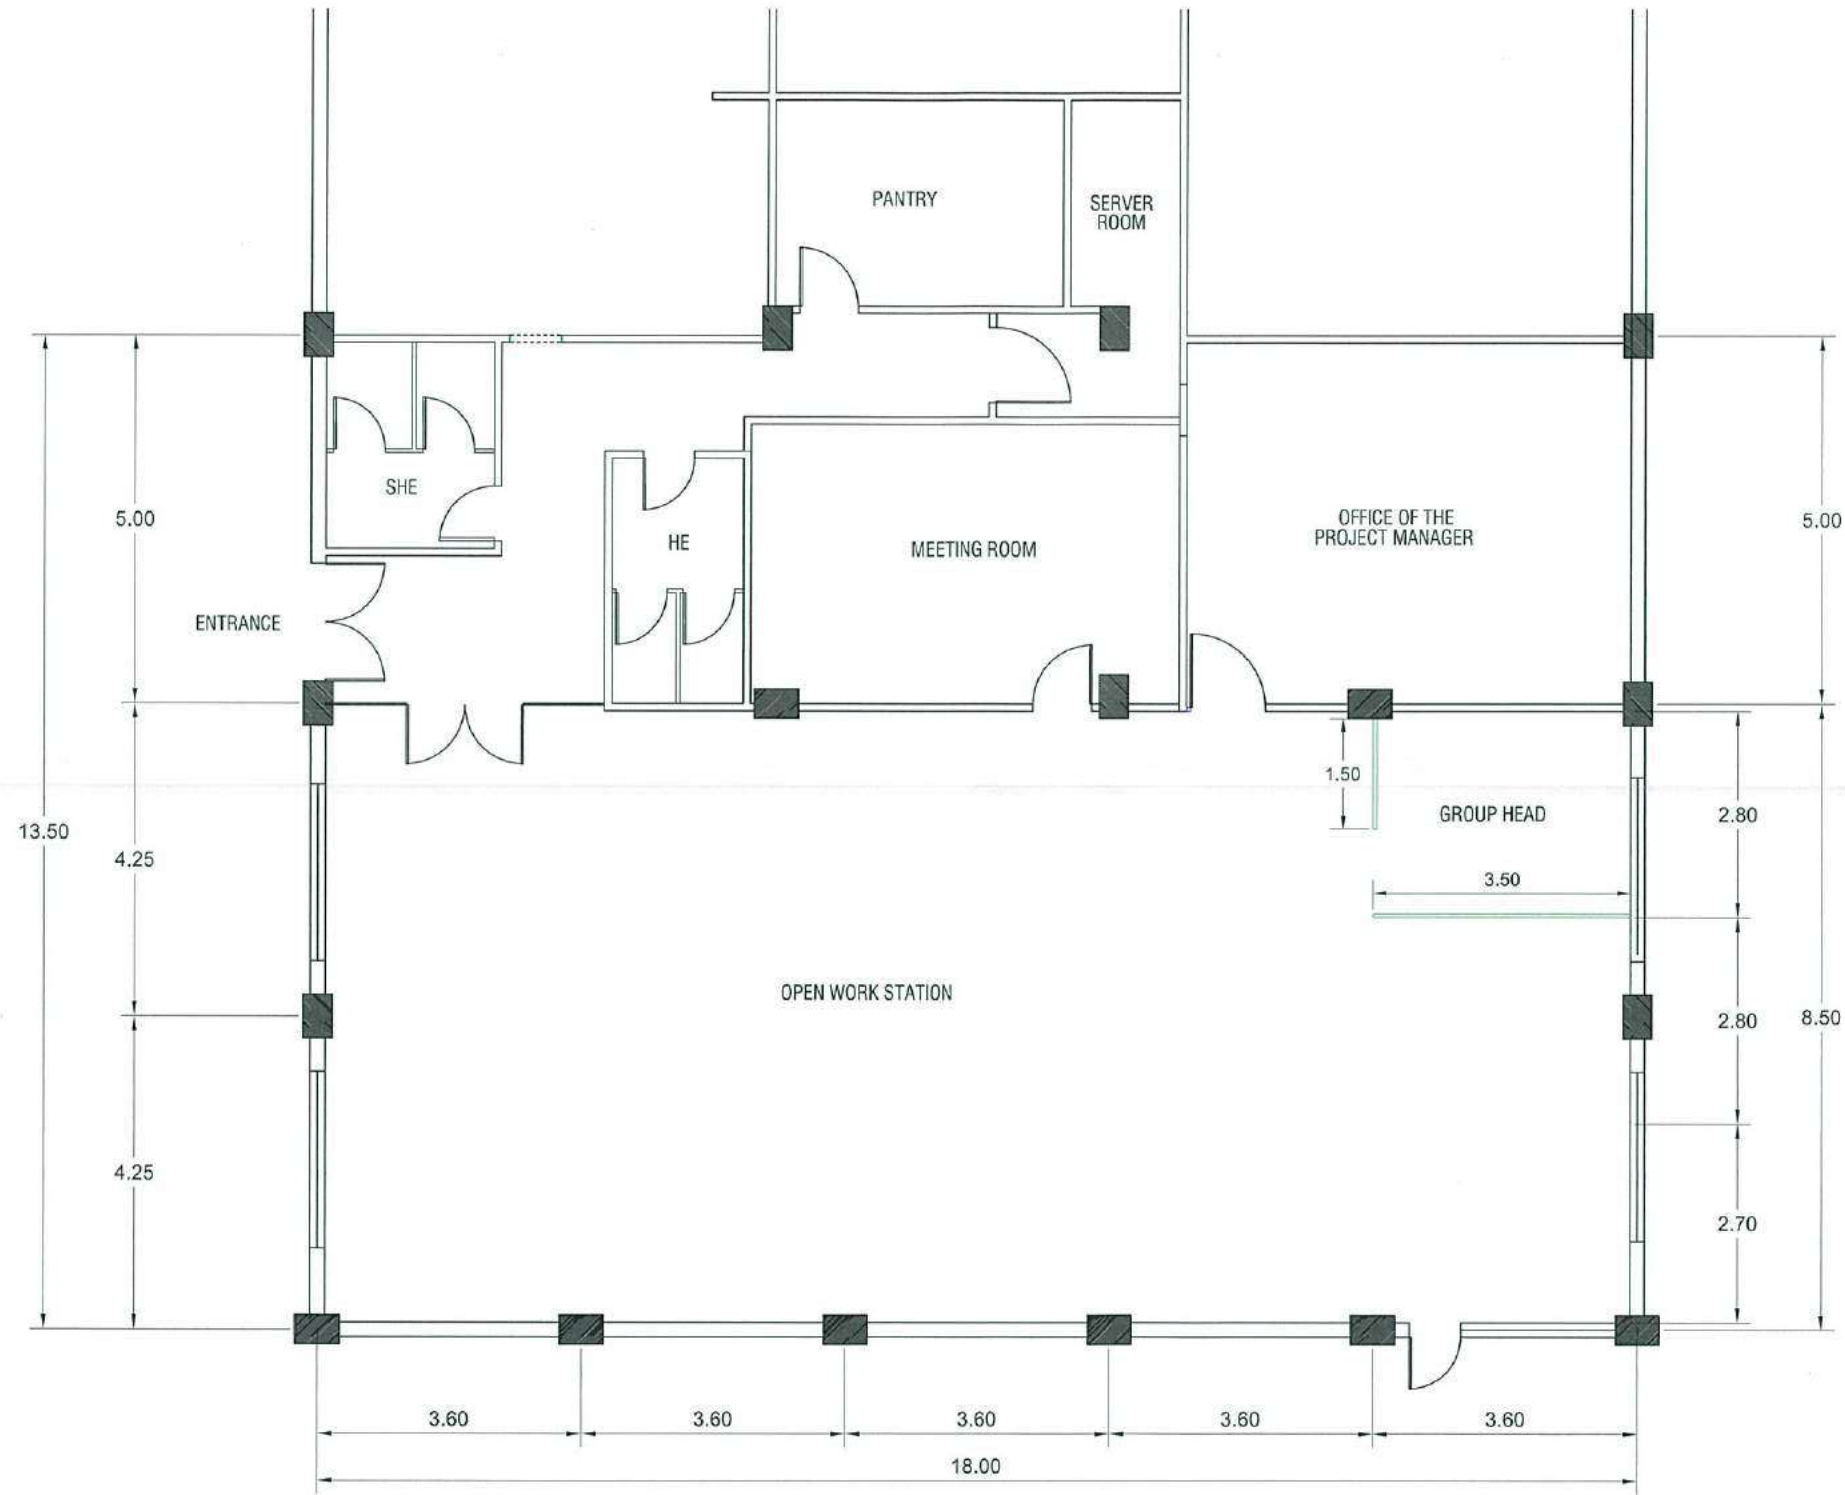

NOTE: FABRIC PARTITION w/ GLASS
 @ 180cm HEIGHT
 COLOR: OFF WHITE



BCDA Bases Conversion and Development Authority	PROJECT NAME PROPOSED SCRP OFFICE CLARK FREE PORT ZONE, PAMPANGA	PREPARED BY AR. JUDENE G. LAGOY ARCHITECT, NCC PMO AR. ALBERT O. REYES CAD OPERATOR, SCRP	CHECKED & REVIEWED BY REYES, LIM PROJECT MANAGER, SCRP	RECOMMENDING APPROVAL AILEEN ANUNCIACION R. ZOSA EXECUTIVE VICE PRESIDENT	APPROVED BY VIVENCIO B. DIZON PRESIDENT AND CEO	SHEET CONTENT LOW PANEL PARTITION PLAN SCALE 1:100 M. DATE: 06-02-2020	SHEET NO. A 03

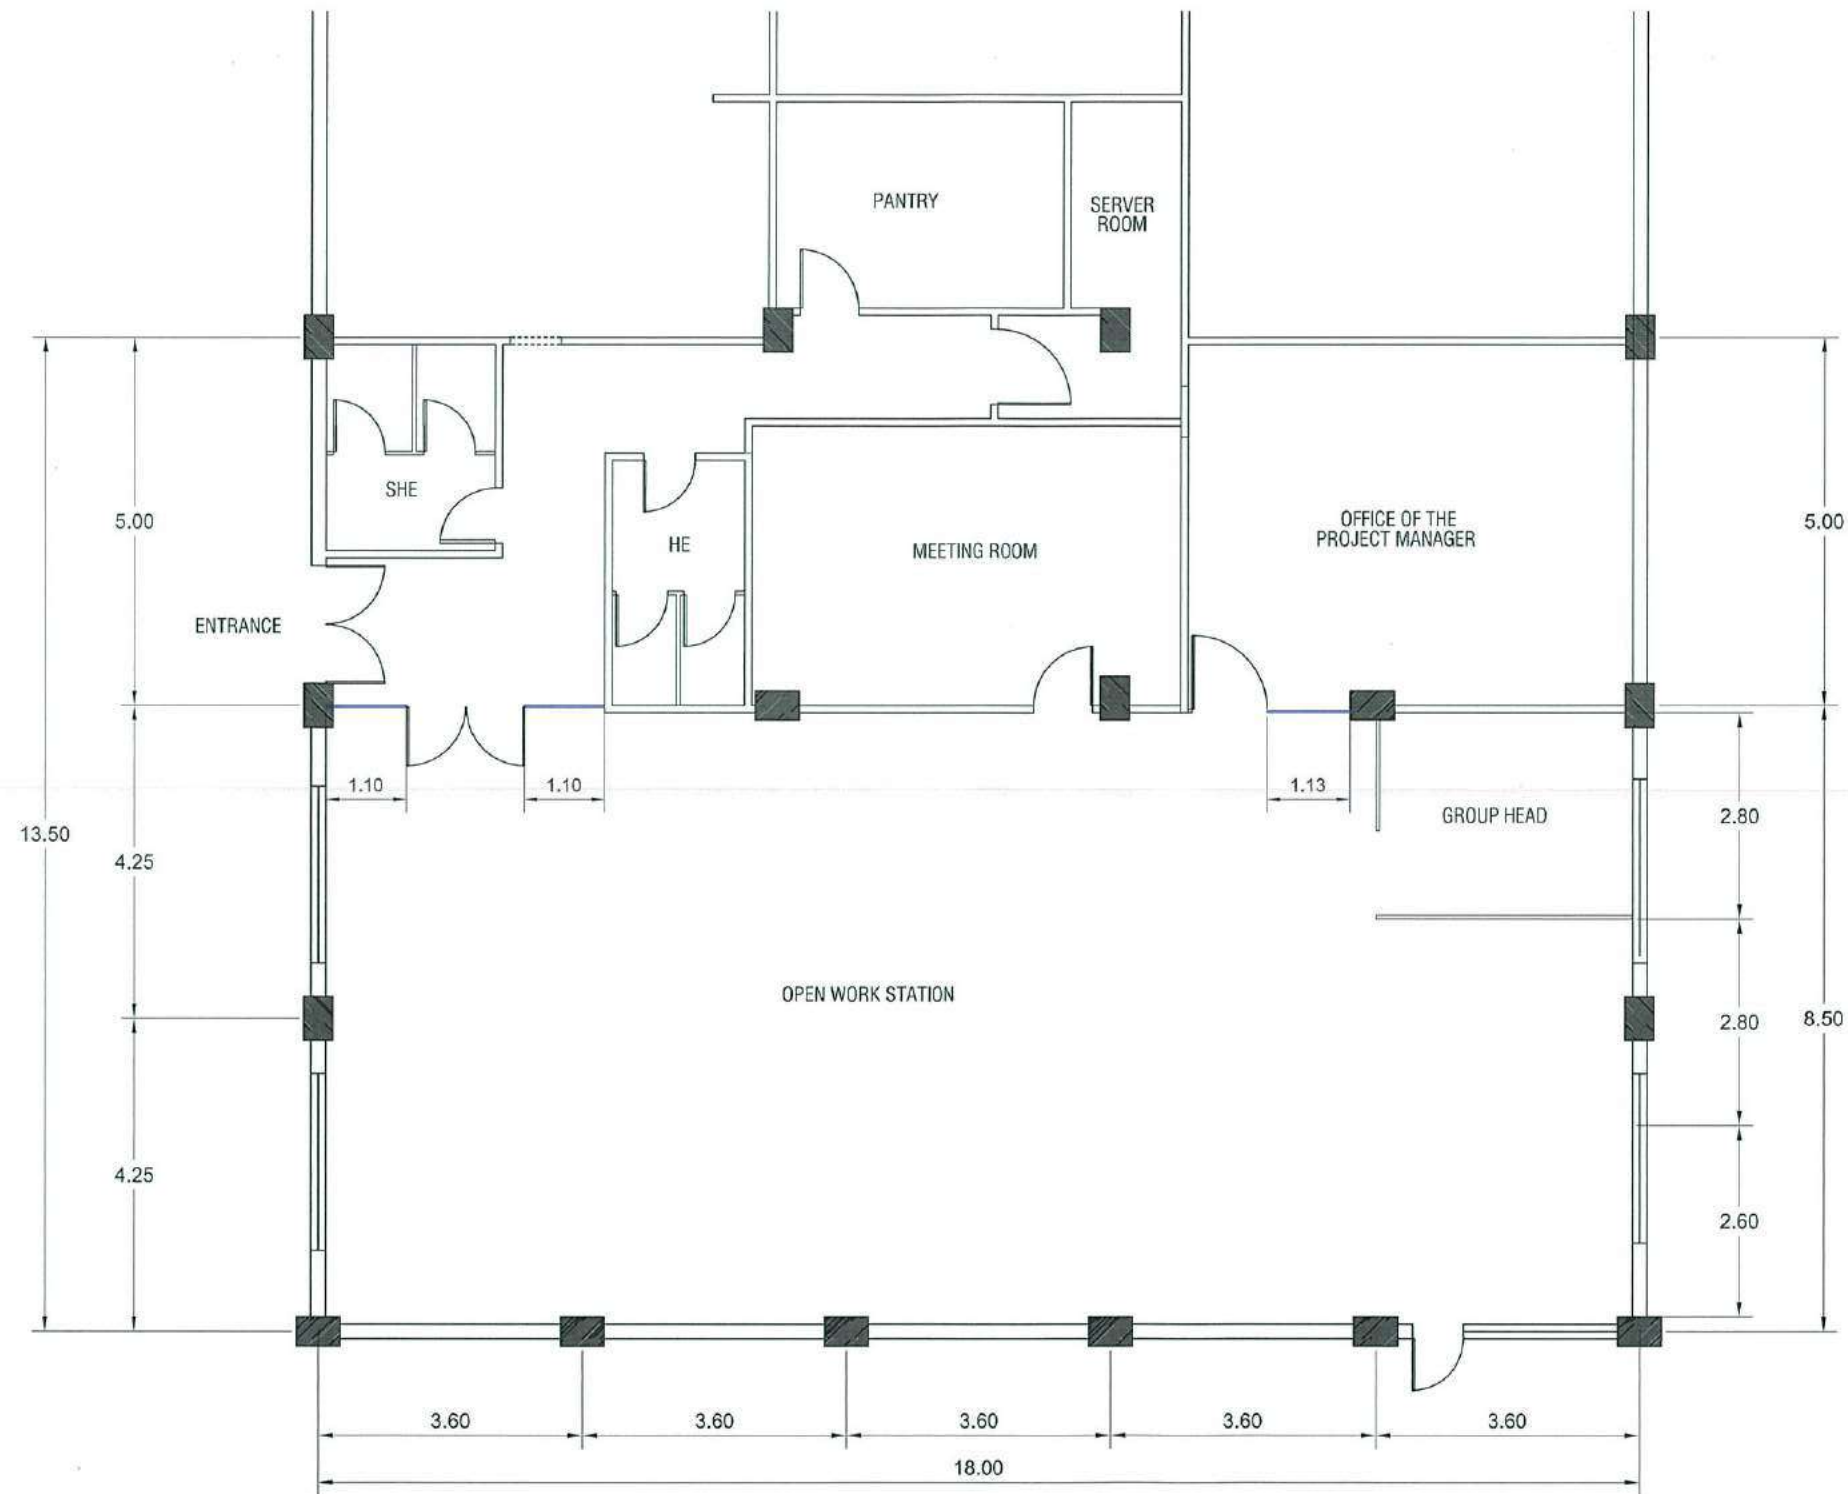

NOTE: 12mm THK. TEMPERED GLASS
ON FD100 TOP & BOTTOM FRAME



PROJECT NAME
PROPOSED SCRIP OFFICE
CLARK FREE PORT ZONE, PAMPANGA

PREPARED BY
AR. JUDENE G. LAGOY
ARCHITECT, NCC PMO
AR. ALBERT G. REYES
CAD OPERATOR, SCRIP

CHECKED & REVIEWED BY
REYS LIM
PROJECT MANAGER, SCRIP

RECOMMENDING APPROVAL
AILEEN ANUNCIACION R. ZOSA
EXECUTIVE VICE PRESIDENT


APPROVED BY
VIVENCIO B. DIZON
PRESIDENT AND CEO

SHEET CONTENT
GLASS PARTITION PLAN
SCALE 1:100 M. DATE: 06-02-2020

SHEET NO.
A
04

30CM X 30CM HOMOGENOUS POLISHED AND UNPOLISHED FLOOR & WALL TILES.

30CM X 30CM VYNIL FLOOR TILES

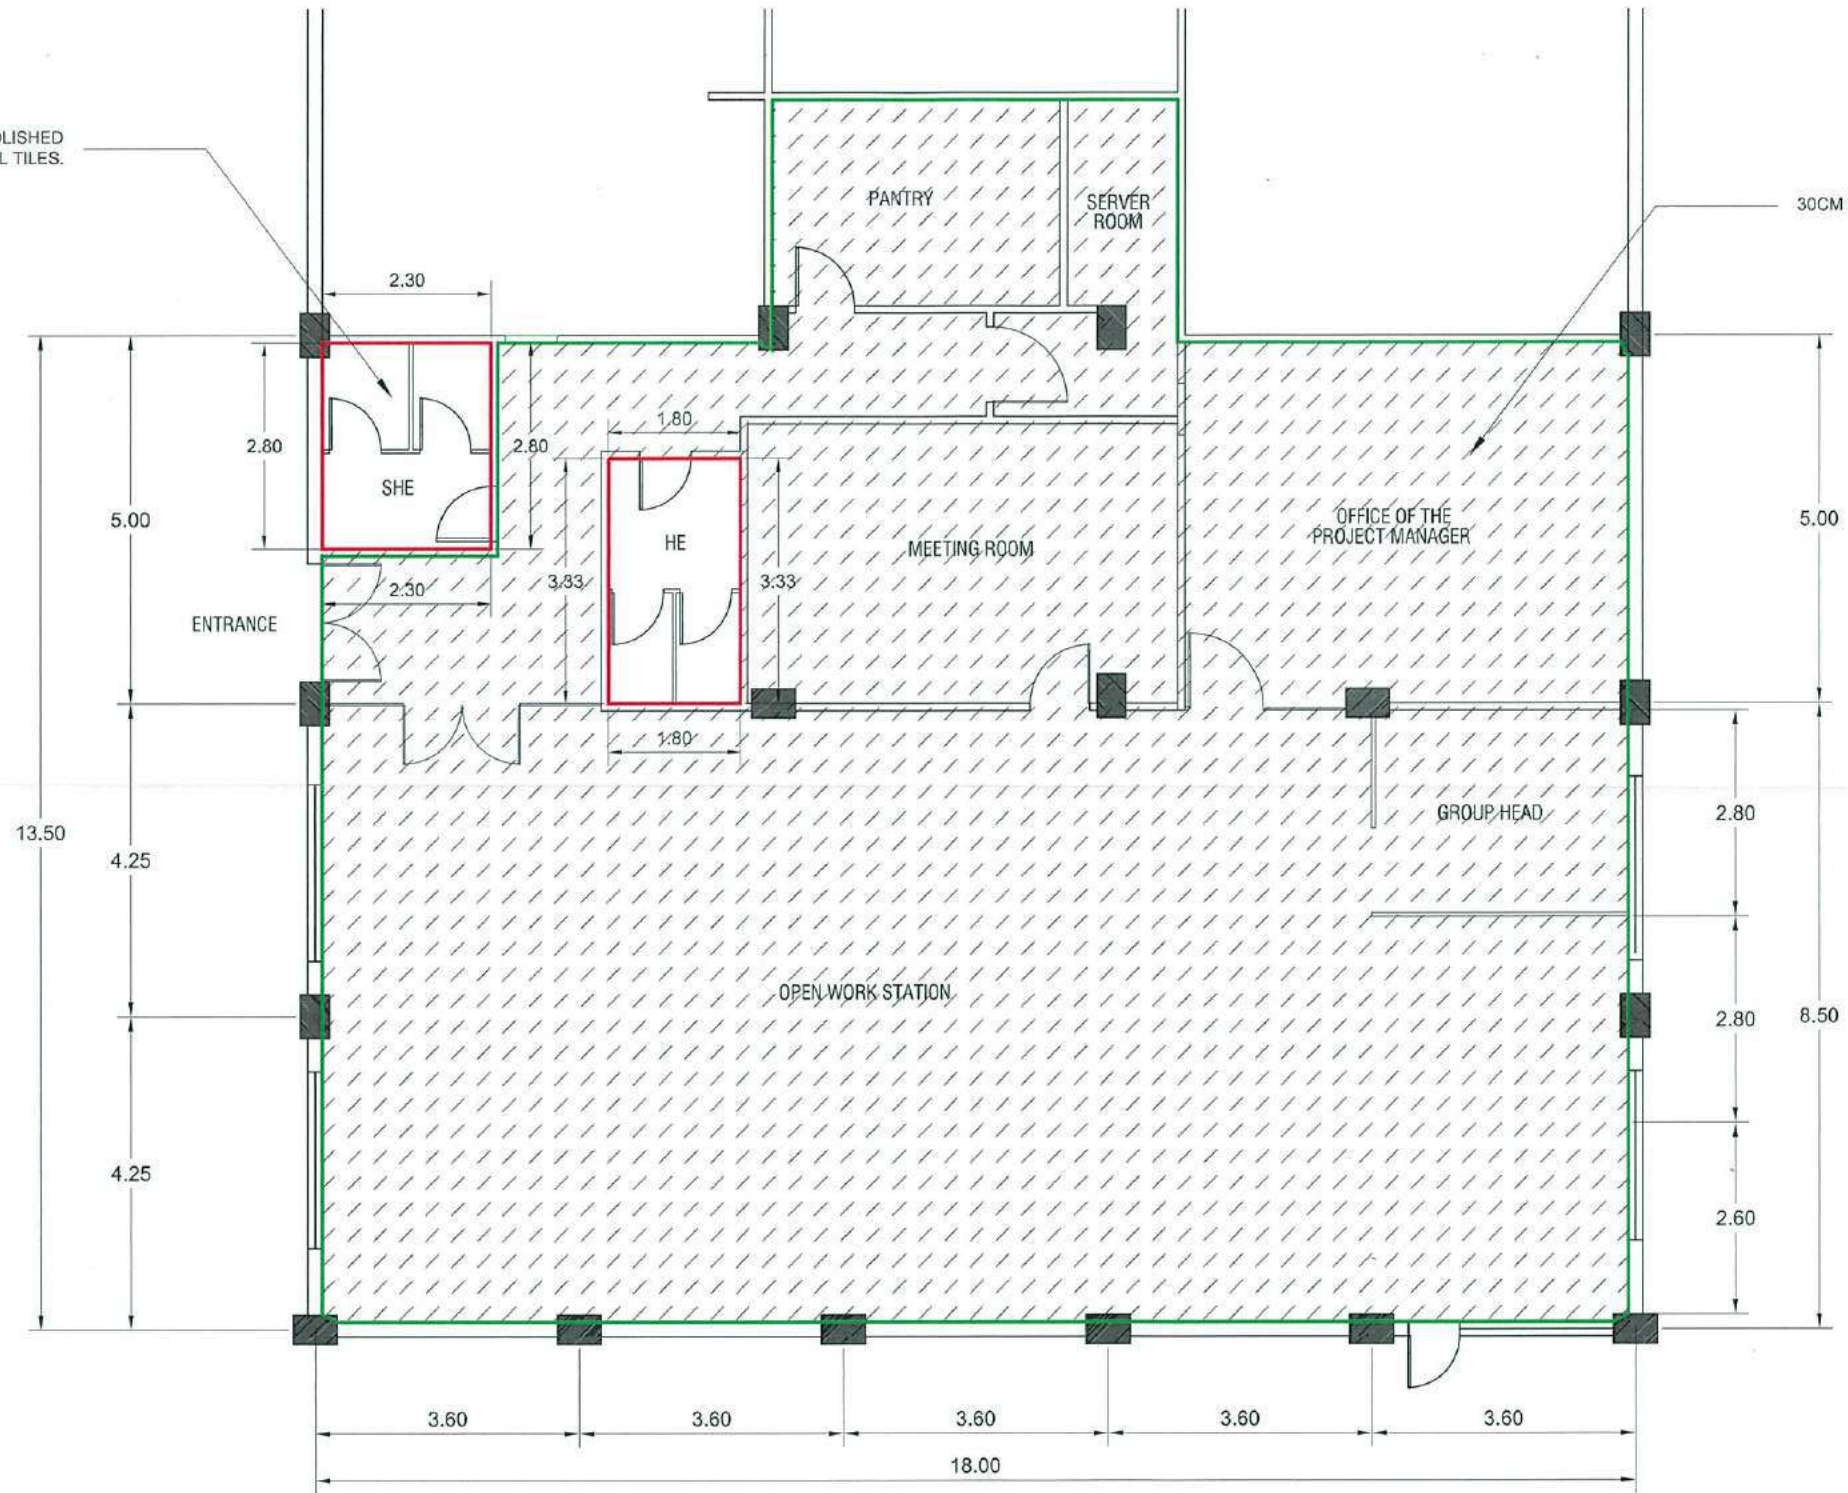


NOTE: TOILET
 30CM X 30CM FLOOR TILES (12.42 M2)
 30CM X 30CM WALL TILES (49.44 M2)

NOTE: WORKING AREA
 30CM X 30CM FLOOR TILES (235 M2)



PROJECT NAME	PREPARED BY	CHECKED & REVIEWED BY	RECOMMENDING APPROVAL	APPROVED BY	SHEET CONTENT	SHEET NO.
PROPOSED SCRP OFFICE CLARK FREE PORT ZONE, PAMPANGA	AR. JUDENE G. LAGOY ARCHITECT IN CHARGE PMO AR. ALBERT G. REYES CAD OPERATOR, SCRP	REY & LIM PROJECT MANAGER SCRP	AILEEN ANUNCIACION R. ZOSA EXECUTIVE VICE PRESIDENT	VIVENCIO B. DIZON PRESIDENT AND CEO	CERAMIC TILES @ TOILET VYNIL TILES @ WORKING AREA	A
					SCALE 1:100 M. DATE: 06-02-2020	05

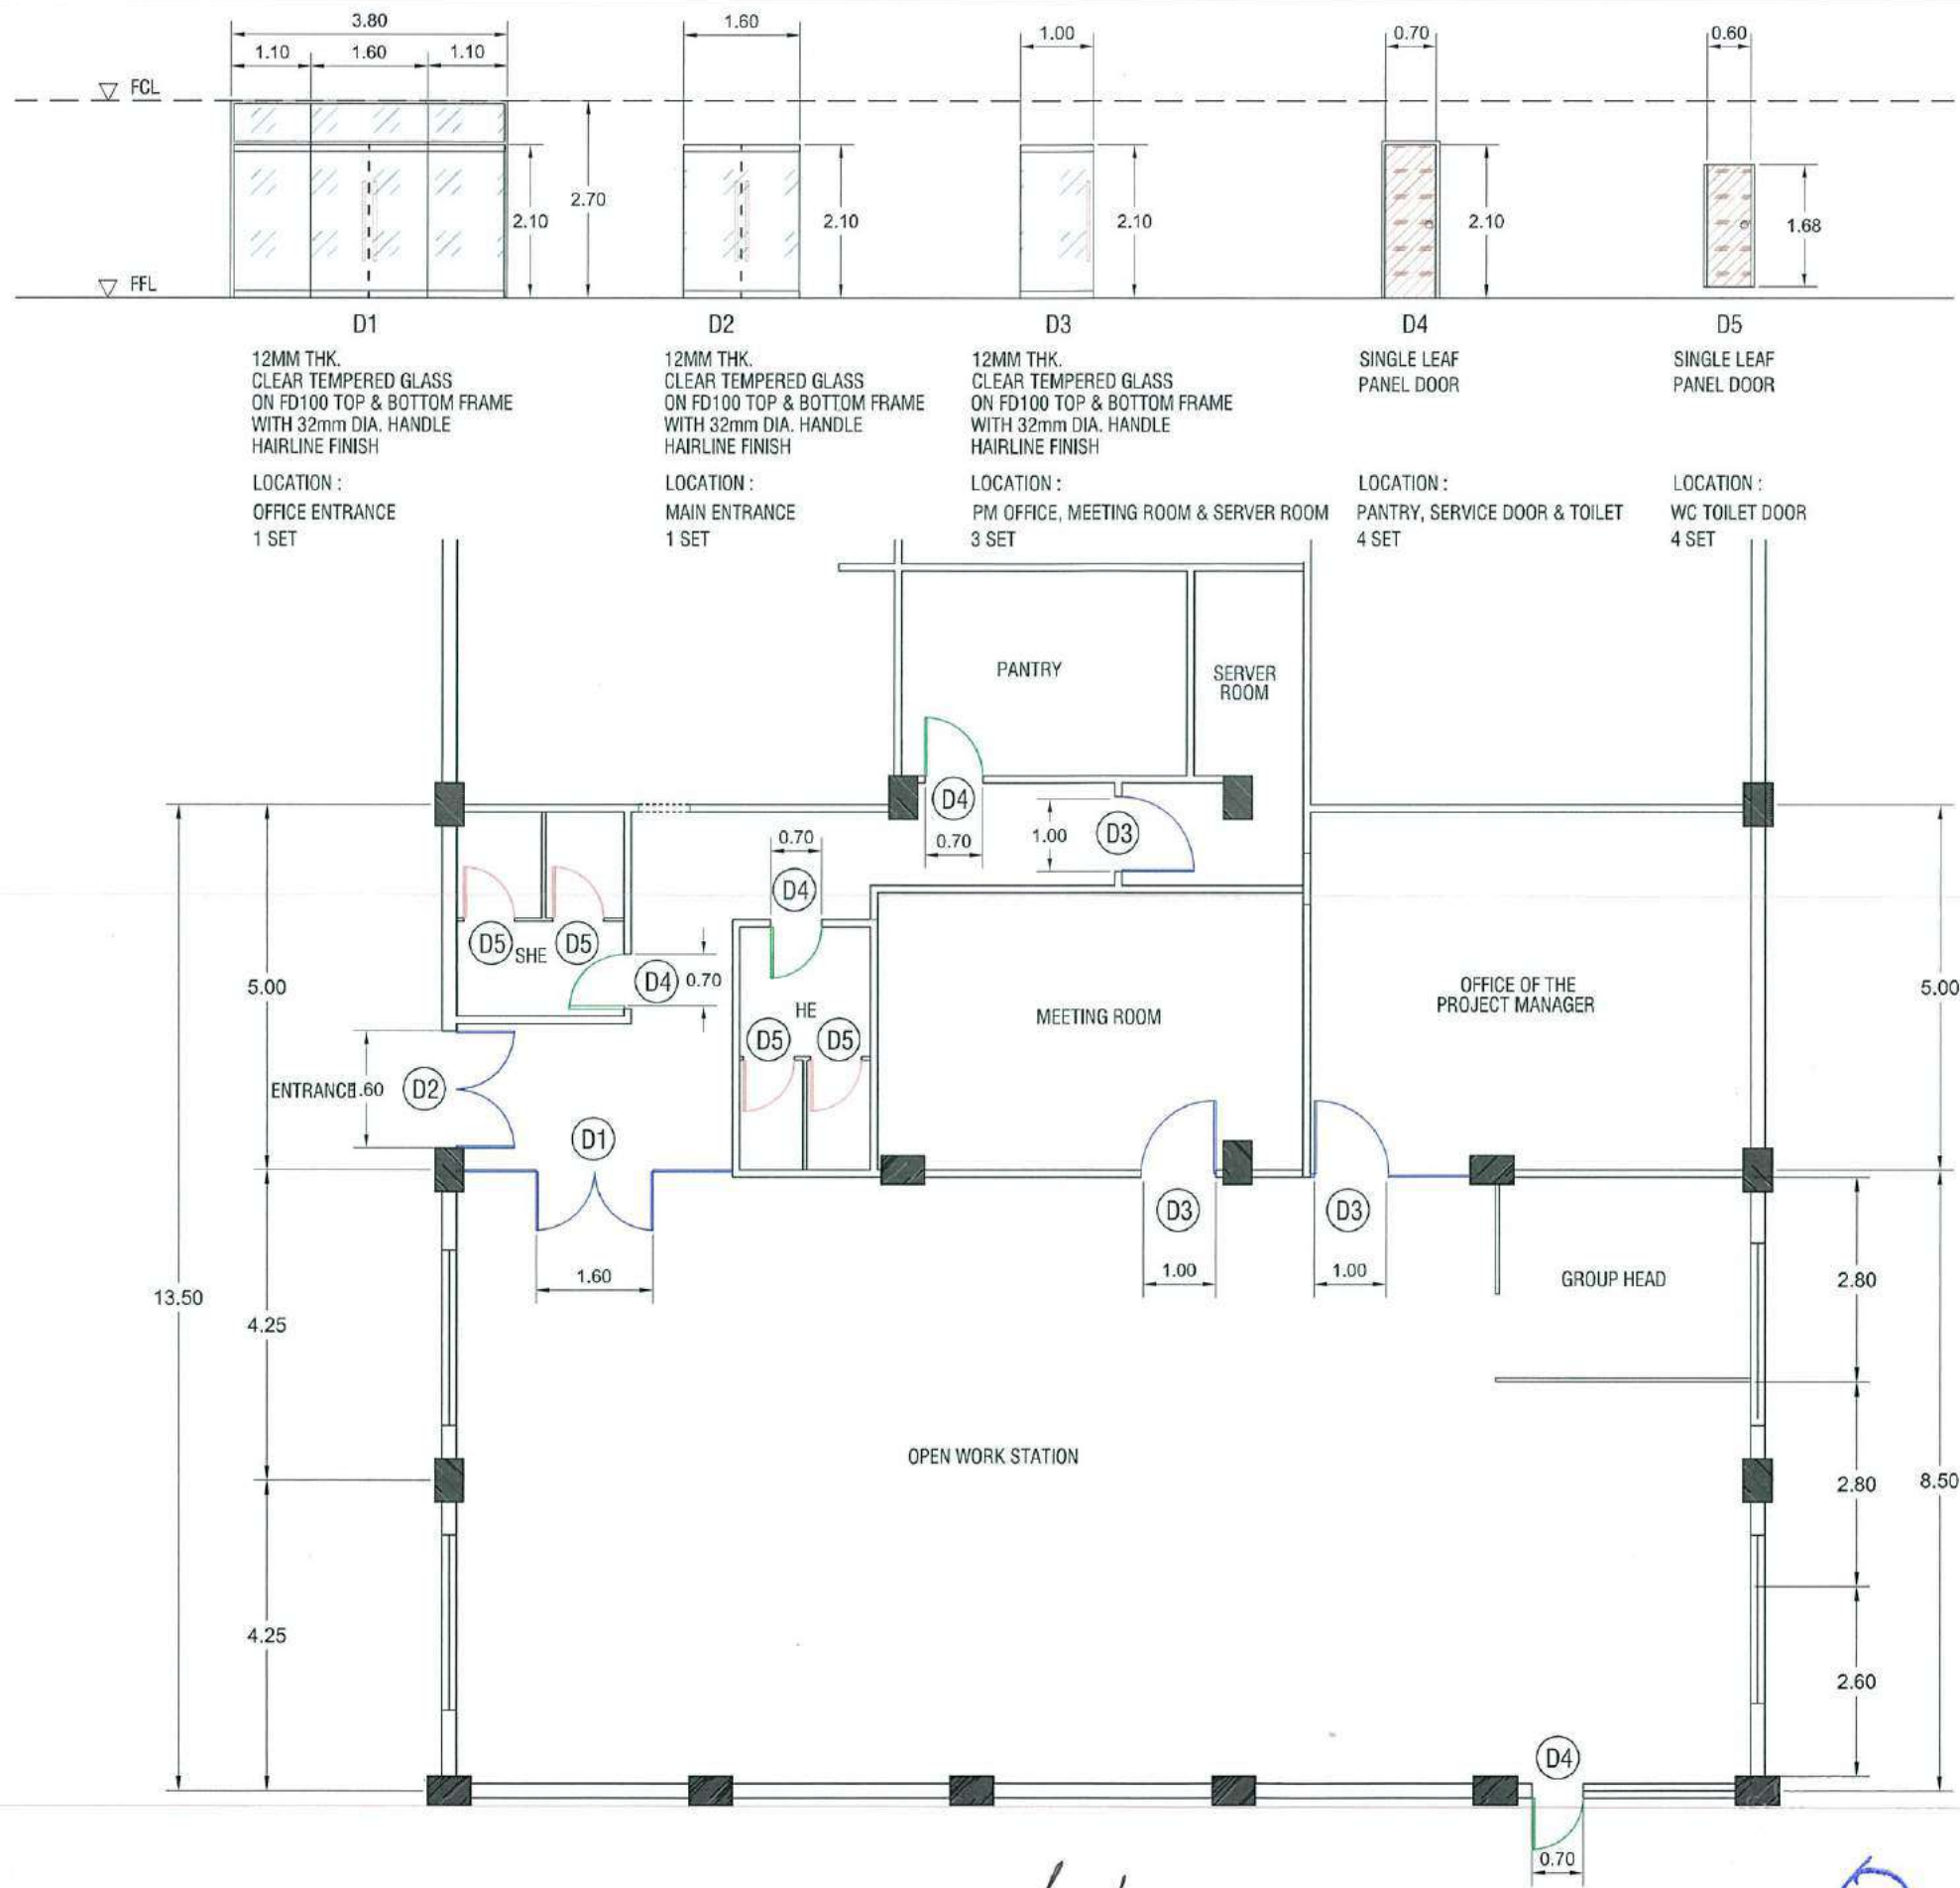

D1	D2	D3	D4	D5
12MM THK. CLEAR TEMPERED GLASS ON FD100 TOP & BOTTOM FRAME WITH 32mm DIA. HANDLE HAIRLINE FINISH	12MM THK. CLEAR TEMPERED GLASS ON FD100 TOP & BOTTOM FRAME WITH 32mm DIA. HANDLE HAIRLINE FINISH	12MM THK. CLEAR TEMPERED GLASS ON FD100 TOP & BOTTOM FRAME WITH 32mm DIA. HANDLE HAIRLINE FINISH	SINGLE LEAF PANEL DOOR	SINGLE LEAF PANEL DOOR
LOCATION : OFFICE ENTRANCE 1 SET	LOCATION : MAIN ENTRANCE 1 SET	LOCATION : PM OFFICE, MEETING ROOM & SERVER ROOM 3 SET	LOCATION : PANTRY, SERVICE DOOR & TOILET 4 SET	LOCATION : WC TOILET DOOR 4 SET



PROJECT NAME
PROPOSED SCRP OFFICE
CLARK FREE PORT ZONE, PAMPANGA

PREPARED BY
AR. JUDENE G. LAGOY
ARCHITECT, NCO PMO
AR. ALBERT G. REYES
CAD OPERATOR, SCRP



CHECKED & REVIEWED BY
REY S. LIM
PROJECT MANAGER, SCRP

RECOMMENDING APPROVAL
AILEEN ANUNCIACION R. ZOSA
EXECUTIVE VICE PRESIDENT


APPROVED BY
VIVENCIO B. DIZON
PRESIDENT AND CEO

SHEET CONTENT
SCALE 1 : 100 M. DATE : 06-02-2020

SHEET NO.
A
06

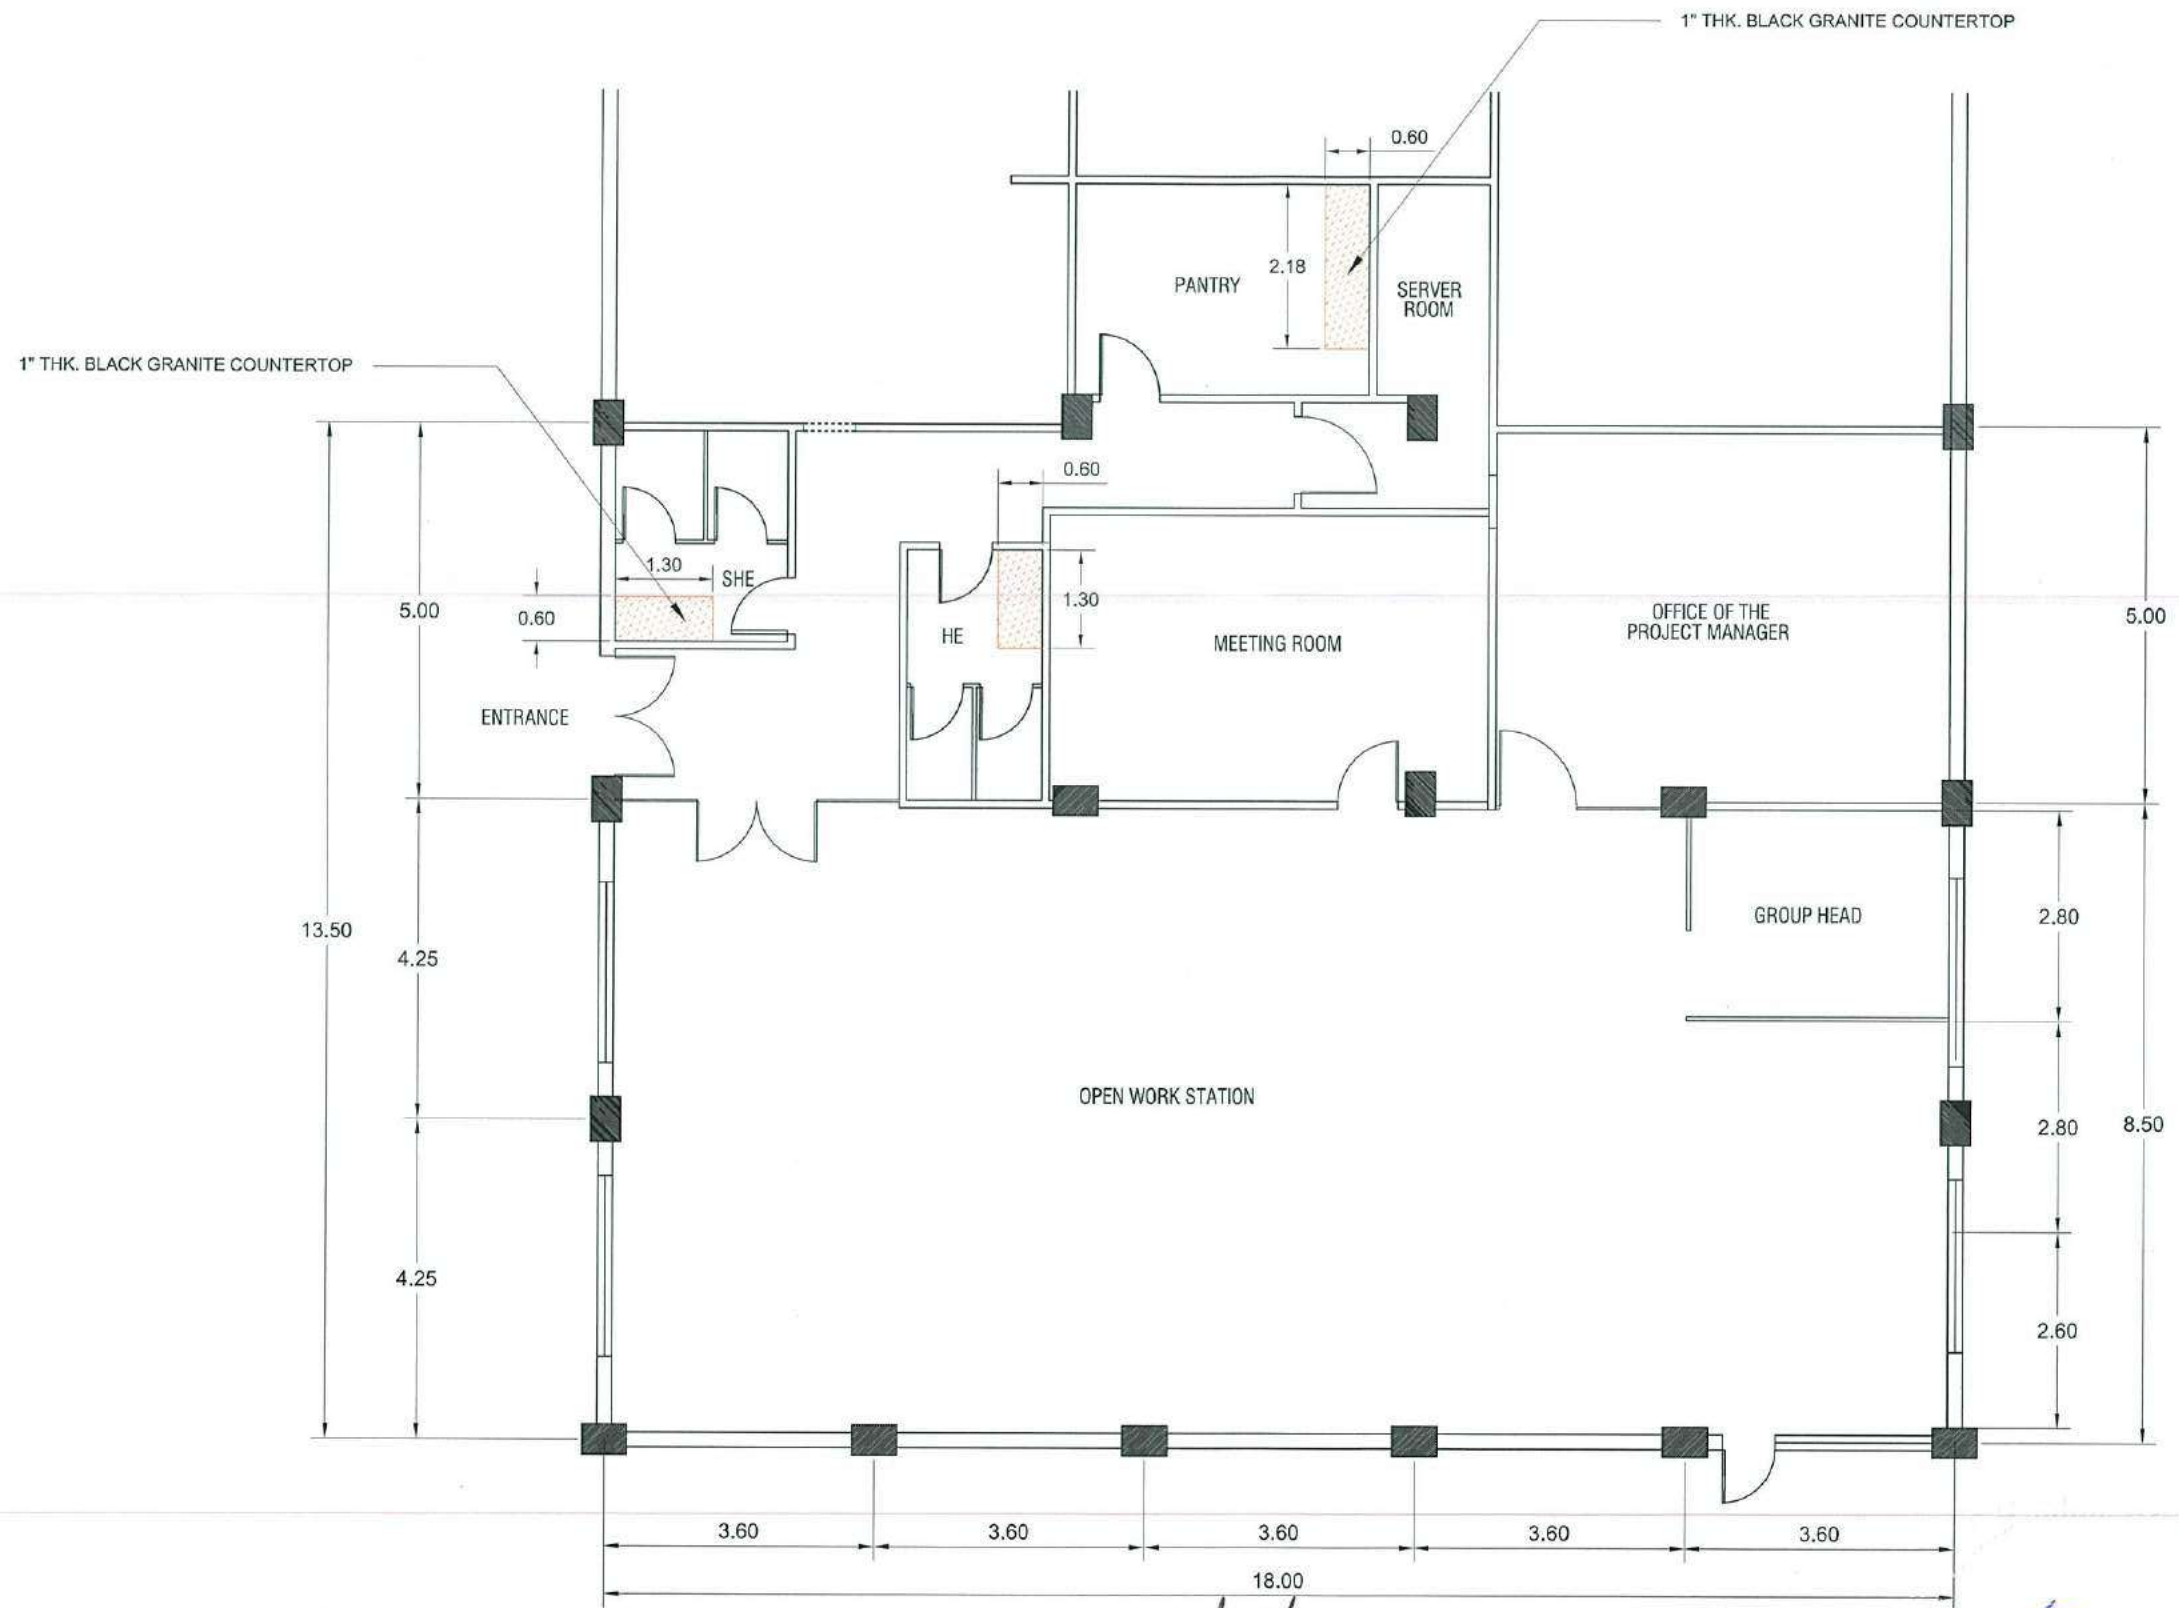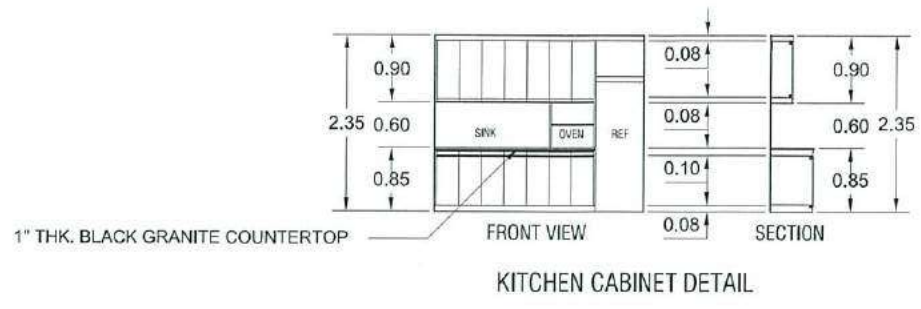

PROJECT NAME	PREPARED BY	CHECKED & REVIEWED BY	RECOMMENDING APPROVAL	APPROVED BY	SHEET CONTENT	SHEET NO.
PROPOSED SCRIP OFFICE CLARK FREE PORT ZONE, PAMPANGA	AR. JUDENE G. LAGOY ARCHITECT, NCC-PMO AR. ALBERT G. REYES CAD OPERATOR, SCRIP	REY S. LIM PROJECT MANAGER, SCRIP	AILEEN ANUNCIACION R. ZOBA EXECUTIVE VICE PRESIDENT	VIVENCIO B. DIZON PRESIDENT AND CEO	GRANITE COUNTER TOP PLAN AND KITCHEN CABINET DETAIL SCALE 1 : 100 M. DATE : 06-02-2020	A 07

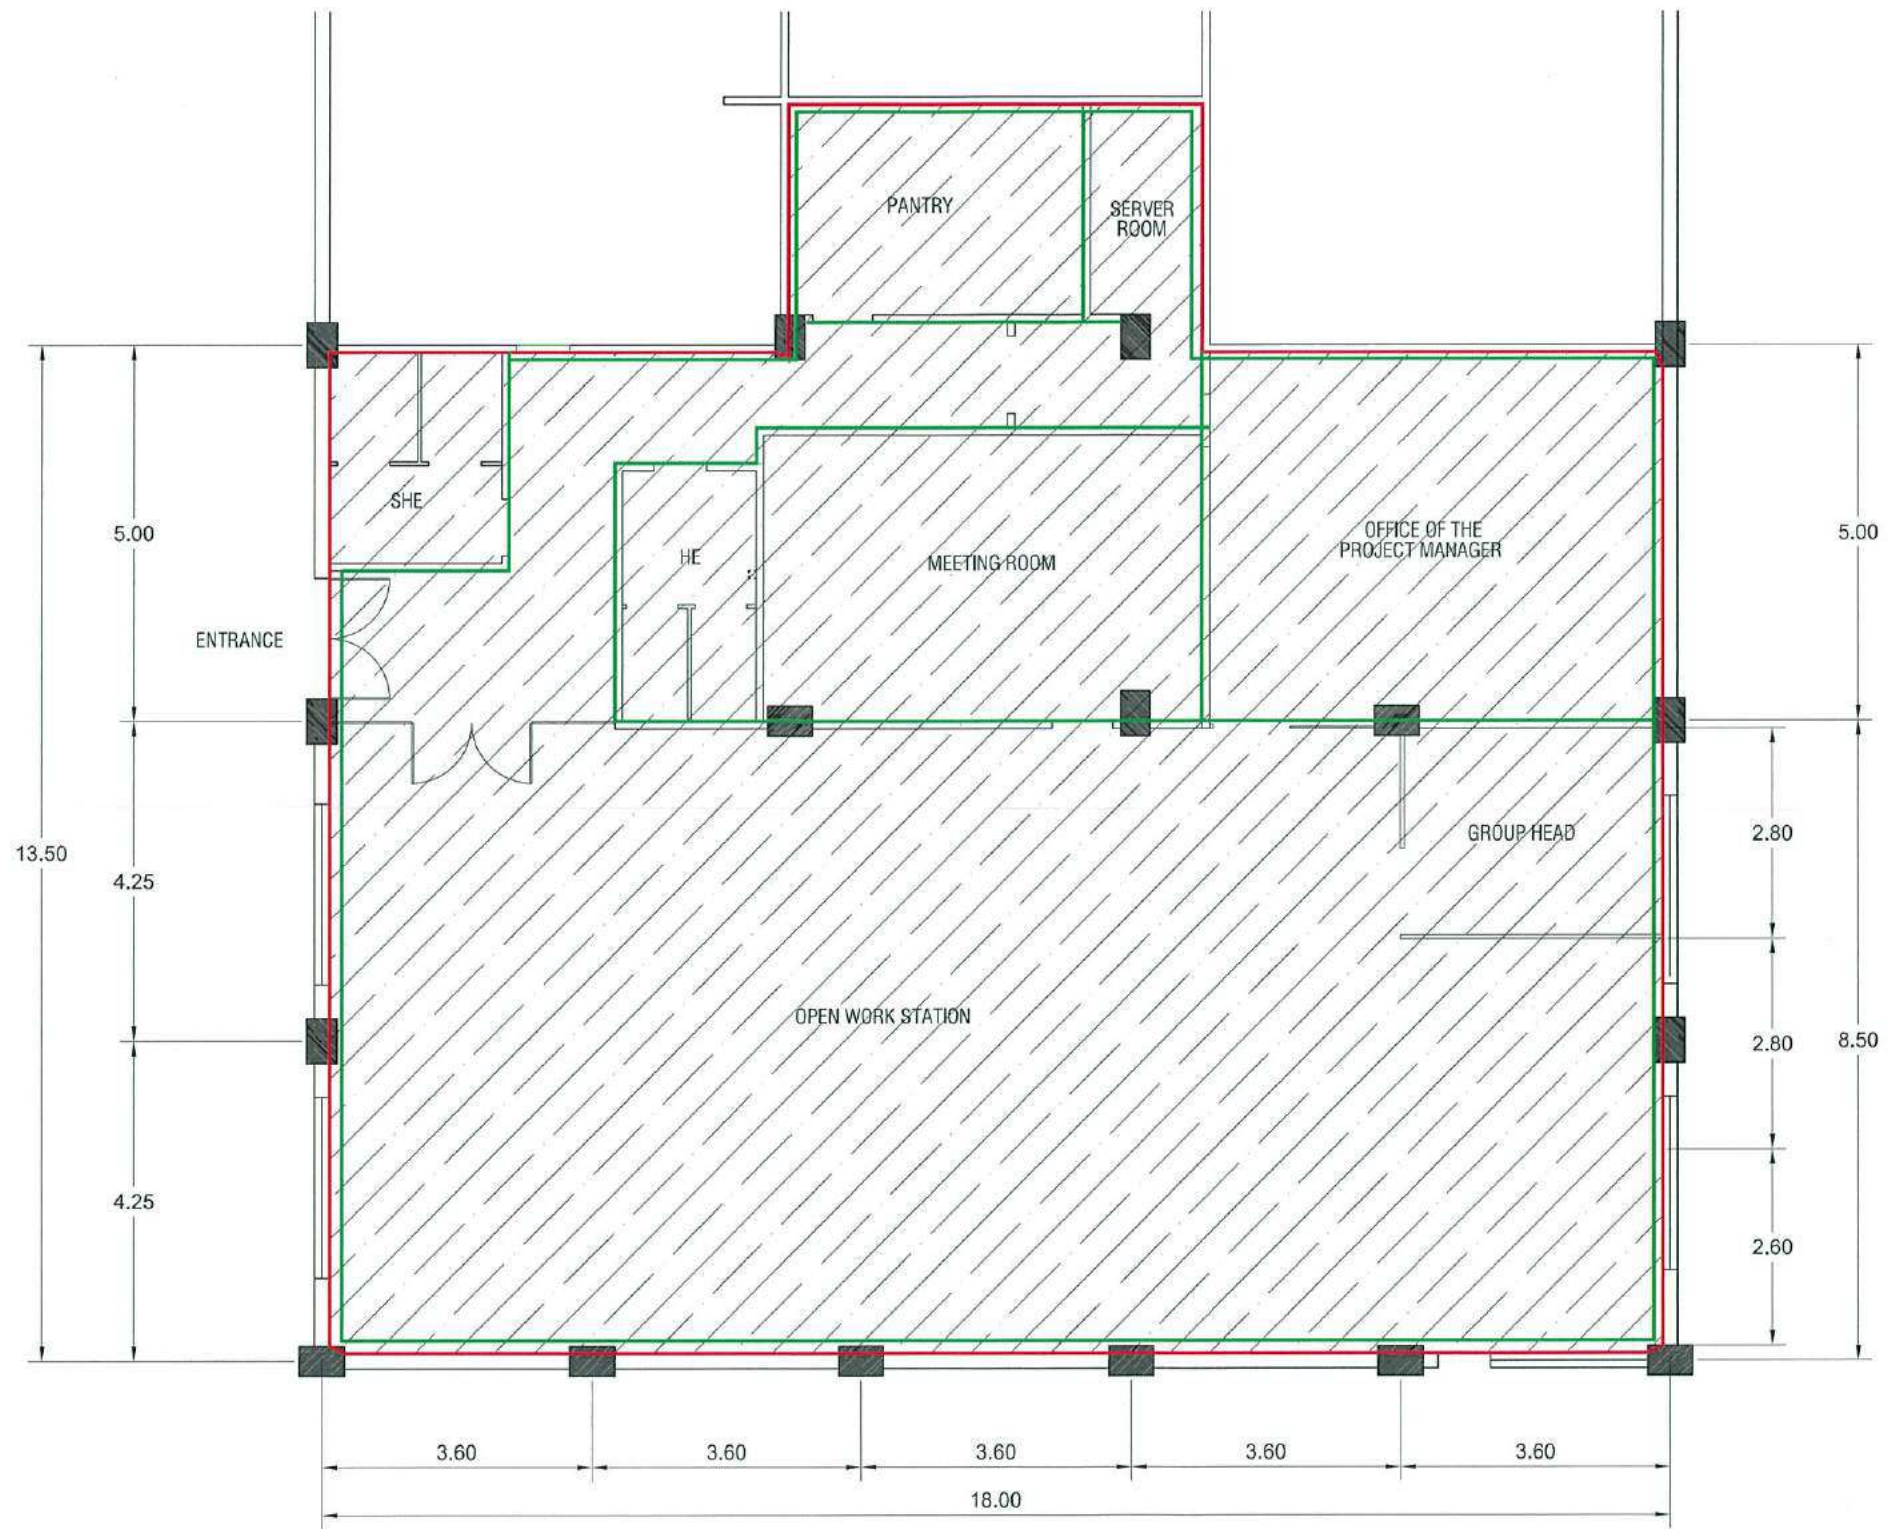

NOTE: PAINTING WORKS

- CEILING - 254 m²
- WALL - 111.90 m²



PROJECT NAME
 PROPOSED SCRP OFFICE
 CLARK FREE PORT ZONE, PAMPANGA

PREPARED BY
 AR. JUDENE G. LAGOY
 ARCHITECT, NCC PMO
 AR. ALBERT S. REYES
 CAD OPERATOR, SCRP


CHECKED & REVIEWED BY
 REY B. LIM
 PROJECT MANAGER, SCRP

RECOMMENDING APPROVAL
 AILEEN ANUNCIACION R. ZOSA
 EXECUTIVE VICE PRESIDENT

APPROVED BY
 VIVENCIO B. DIZON
 PRESIDENT AND CEO

SHEET CONTENT
 PAINTING WORKS PLAN
 SCALE 1 : 100 M. DATE : 06-02-2020


SHEET NO.
 A
 08

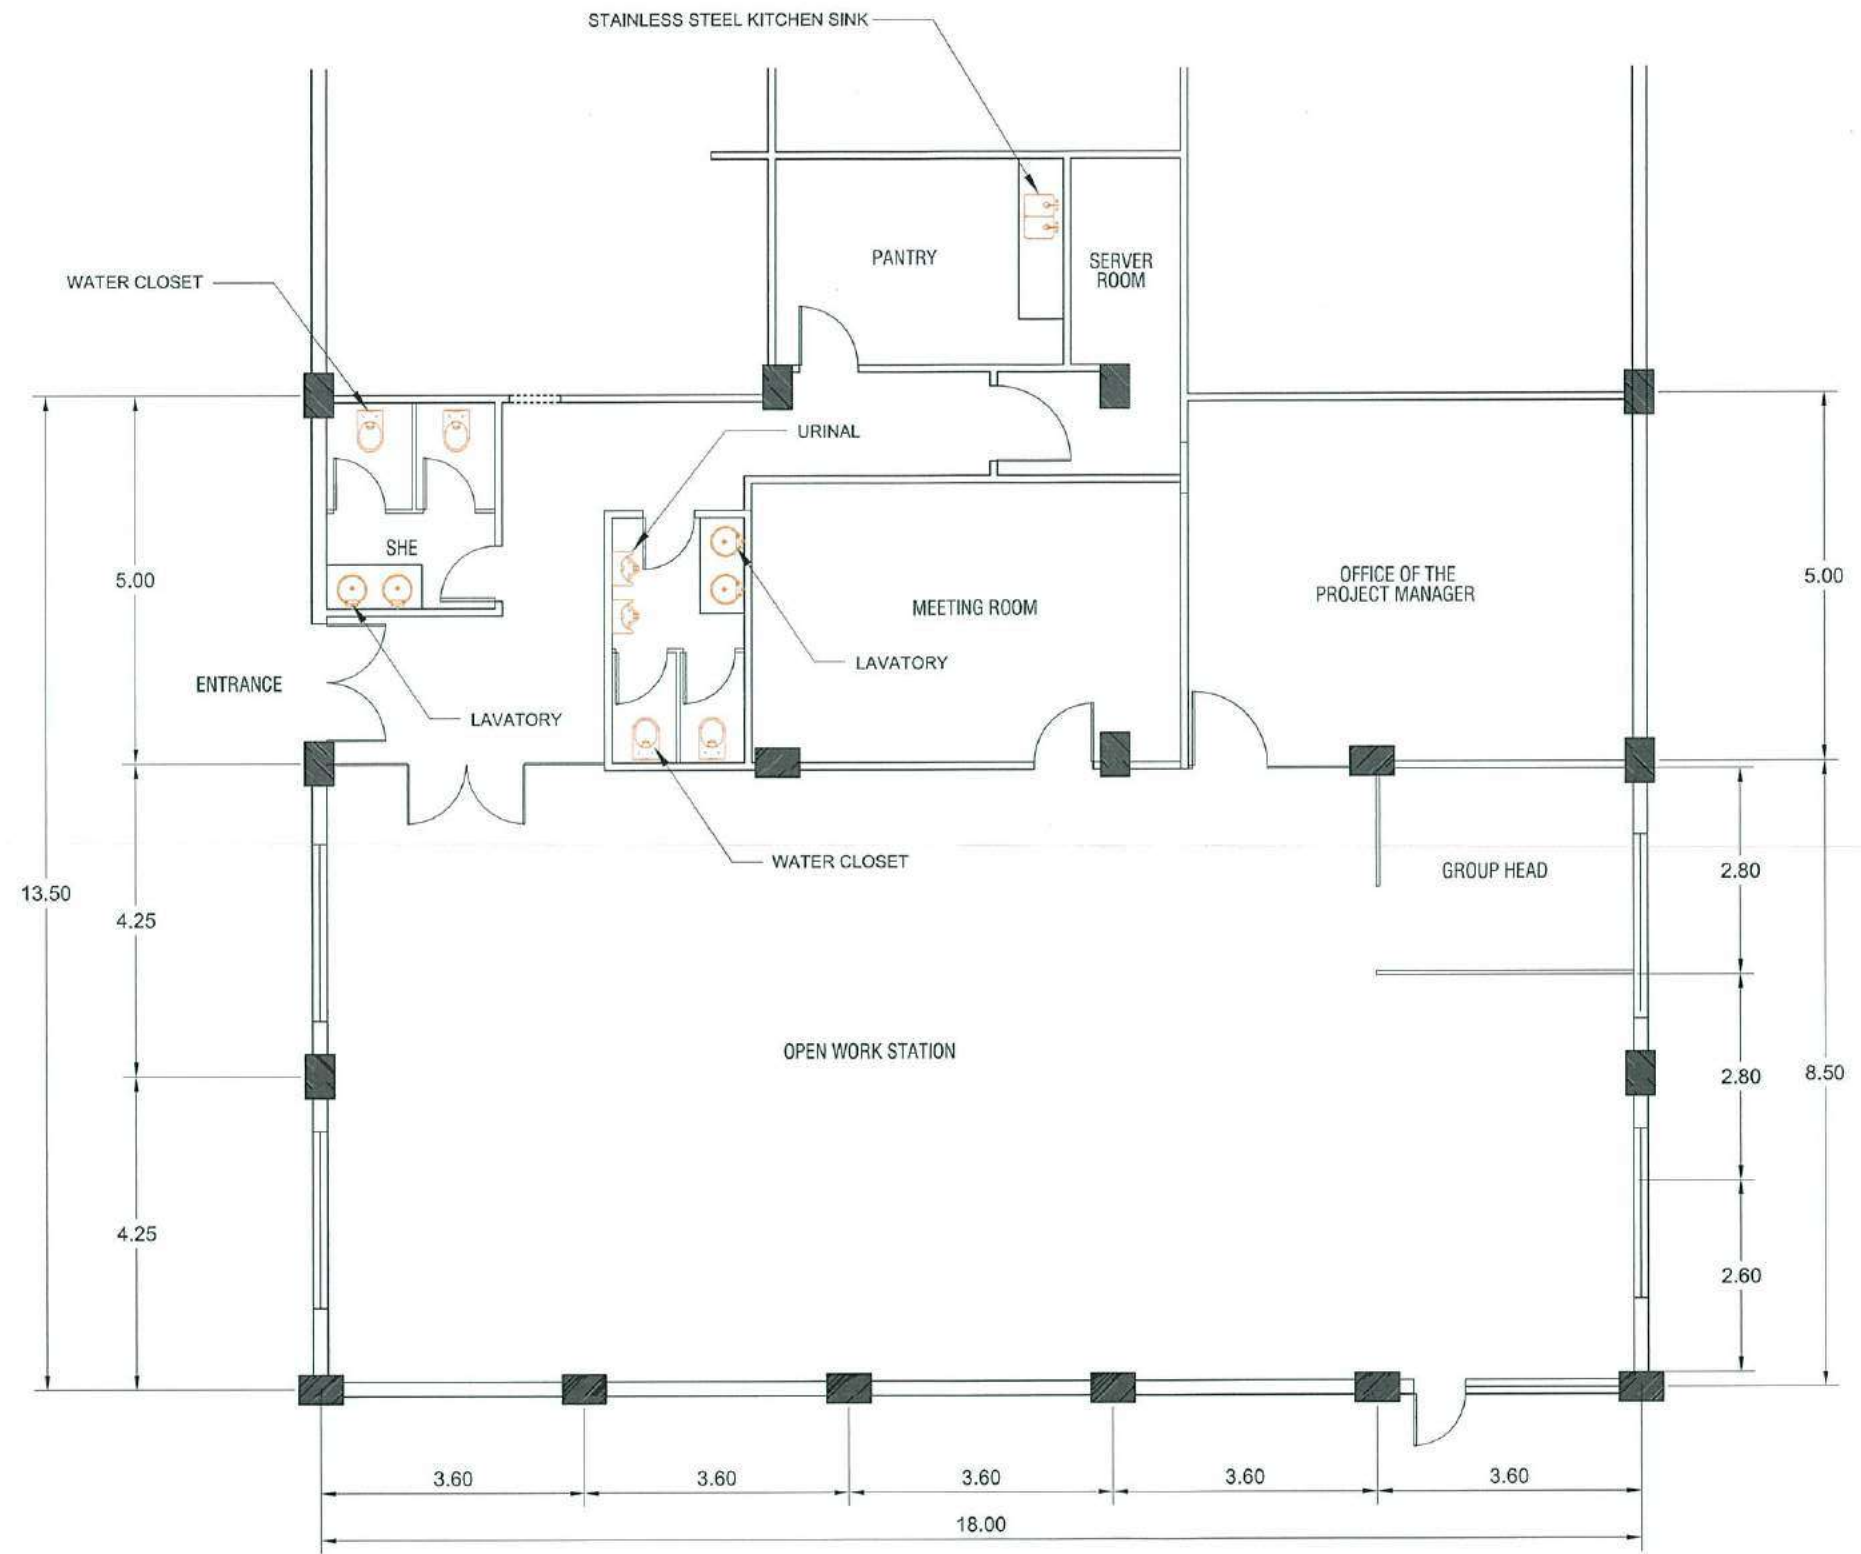

NOTE: 4 SET WATER CLOSET
 4 SET LAVATORY
 2 SET URINAL
 1 SET KITCHEN SINK (DOUBLE)



PROJECT NAME	PREPARED BY	CHECKED & REVIEWED BY	RECOMMENDING APPROVAL	APPROVED BY	SHEET CONTENT	SHEET NO.
PROPOSED SCRIP OFFICE CLARK FREE PORT ZONE, PAMPANGA	AR. JUDENE G. LAGOY ARCHITECT, NCC-PMO AR. ALBERT G. REYES CAD OPERATOR, SCRIP	REY S. LIM PROJECT MANAGER, SCRIP	AILEEN ANUNCIACION R. ZOSA EXECUTIVE VICE PRESIDENT	VIVENCIO B. DIZON PRESIDENT AND CEO	PLUMBING FIXTURES PLAN SCALE 1:100 M. DATE: 05-02-2020	A 09


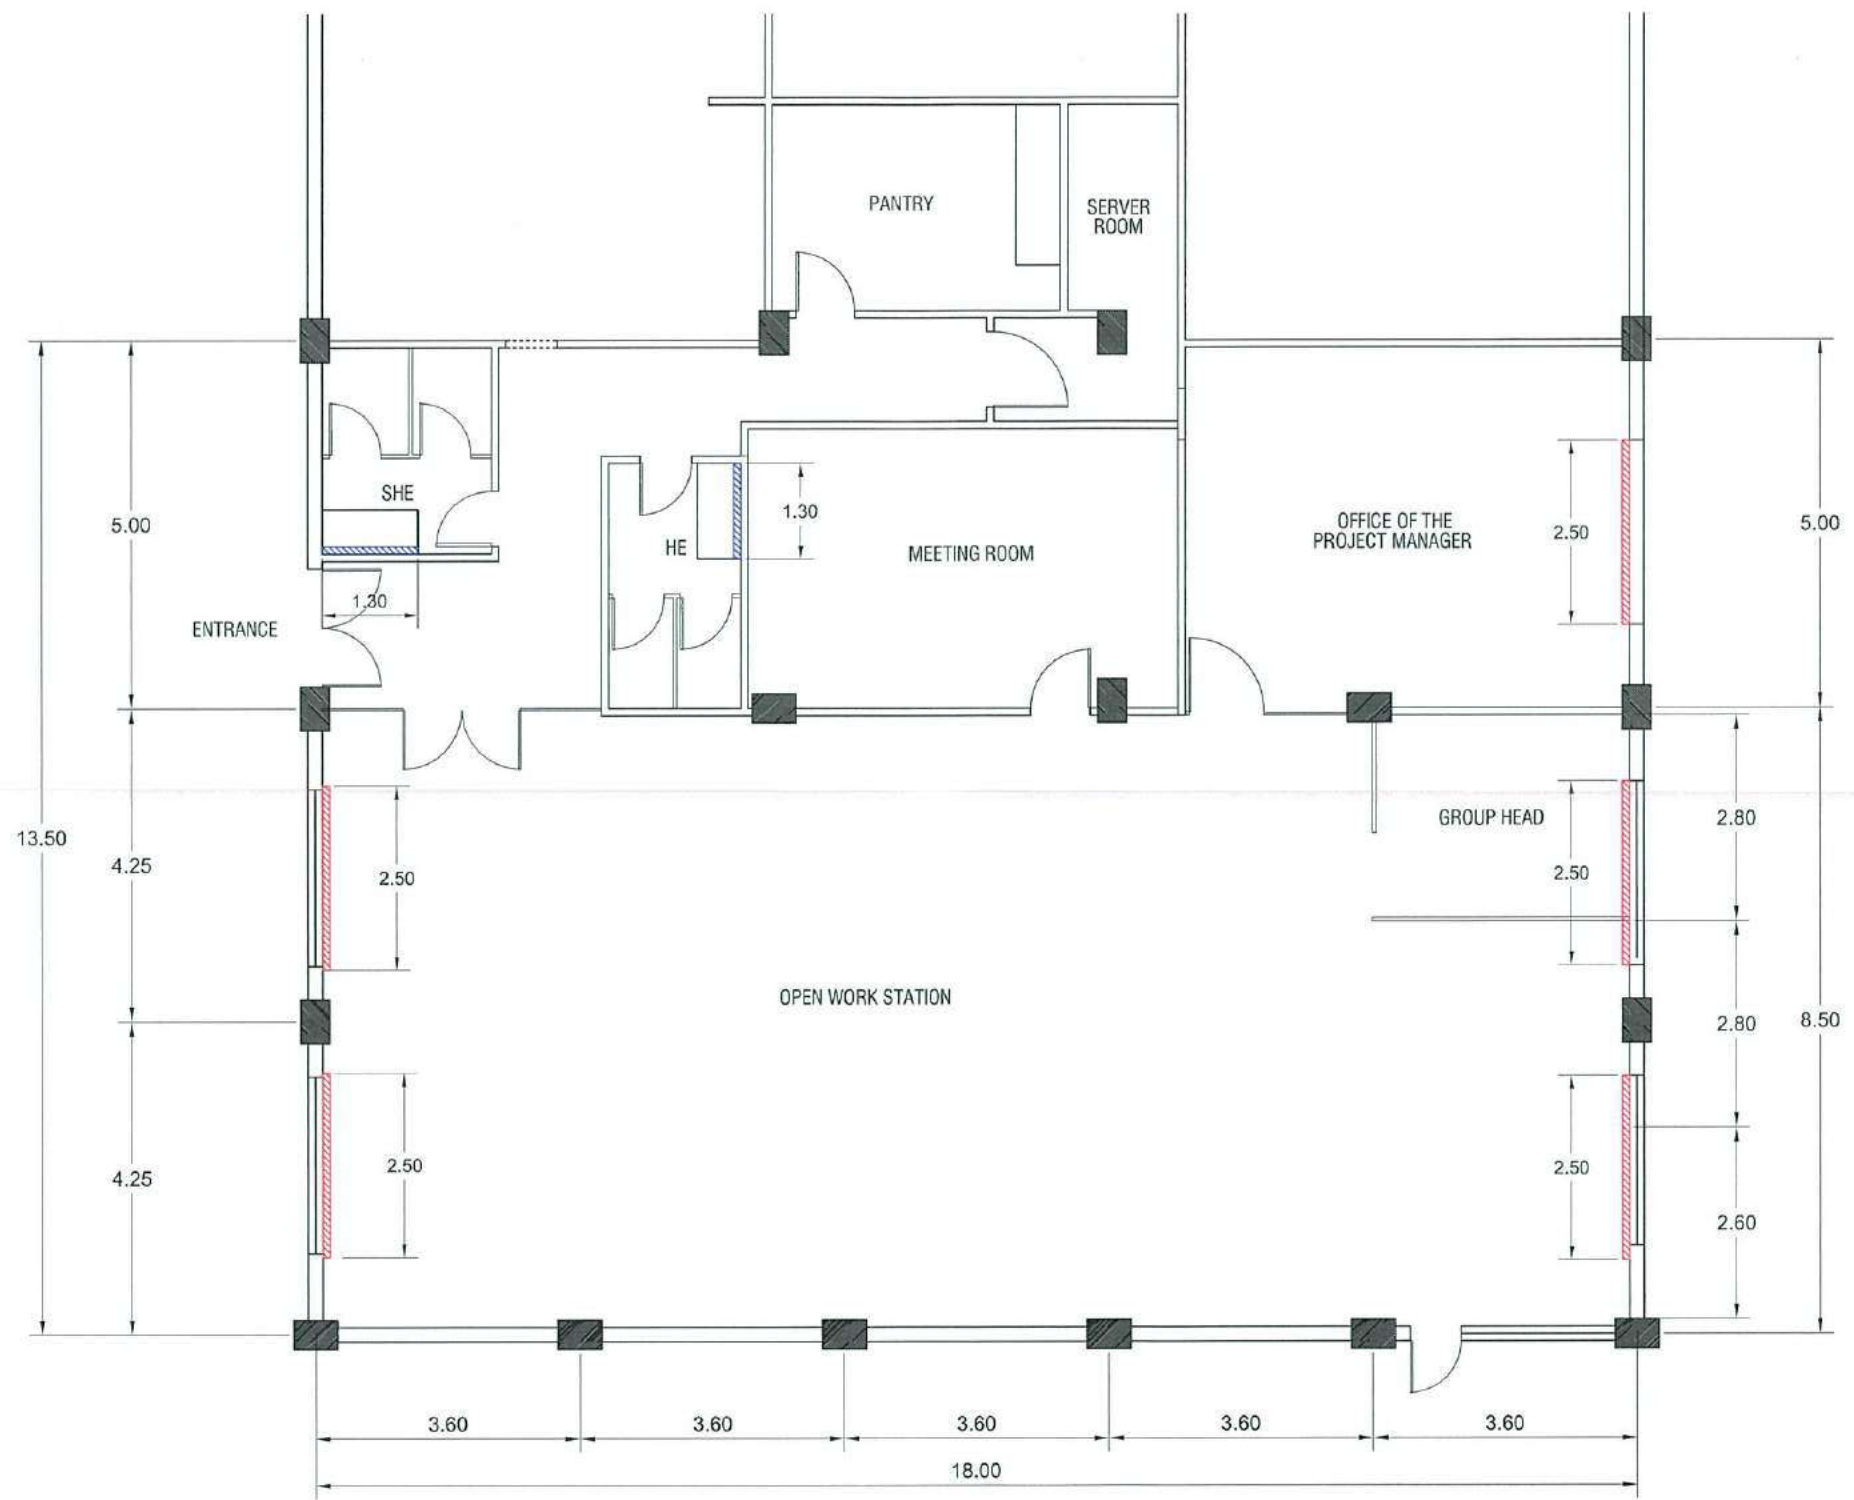


- 5 SET WINDOW BLINDS (ROLL UP)
- 2 PCS. CLEAR GLASS FRAMELESS MIRROR




BCDA Bases Conversion and Development Authority	PROJECT NAME	PREPARED BY	CHECKED & REVIEWED BY	RECOMMENDING APPROVAL	APPROVED BY	SHEET CONTENT	SHEET NO.
	PROPOSED SCRP OFFICE CLARK FREE PORT ZONE, PAMPANGA	AR. JUDENE G. LAGOY ARCHITECT, NCC PMO AR. ALBERT S. REYES CAD OPERATOR, SCRP	 REY S. LIM PROJECT MANAGER SCRP	 AILEEN ANUNCIACION R. ZOSA EXECUTIVE VICE PRESIDENT	 VIVENCIO B. DIXON PRESIDENT AND CEO	WINDOW BLINDS & MIRROR SCALE: 1 : 100 M. DATE : 06-02-2020	A 10


FLUID APPLIED WATERPROOFING MEMBRANE
MINIMUM DRY FILM 55 MILS THICK
BELOW FLOOR FINISH

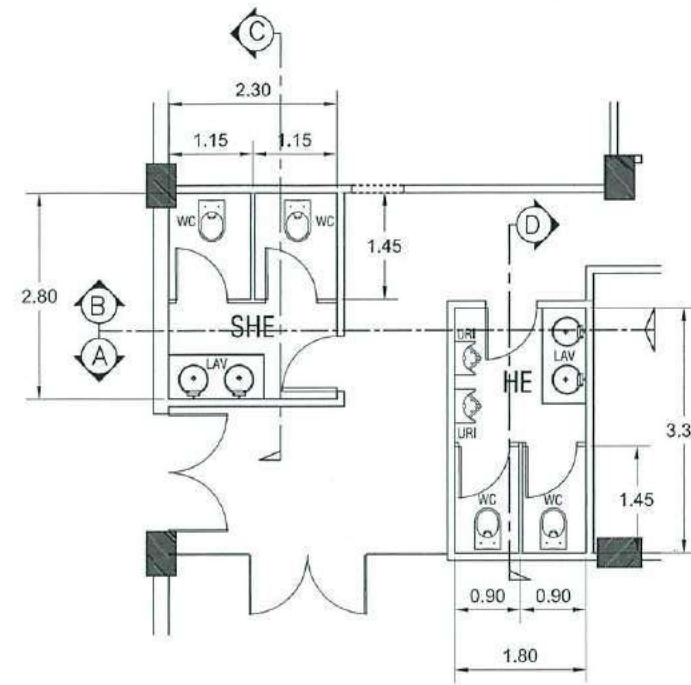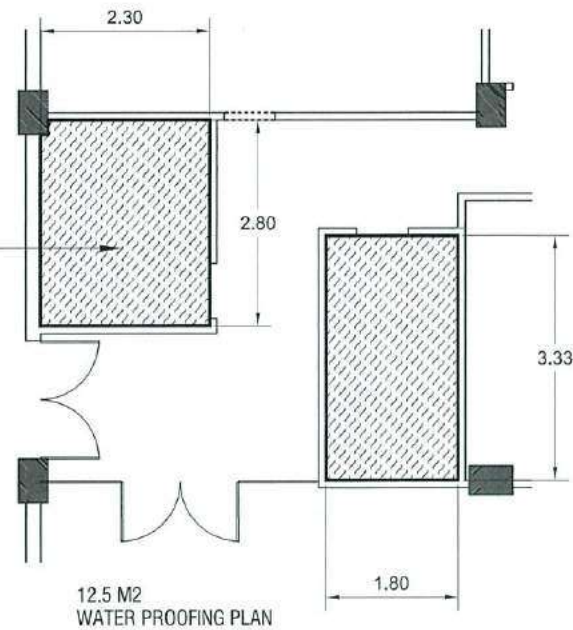


MENS & WOMENS TOILET
TYPICAL PLAN
SCALE 1:100M

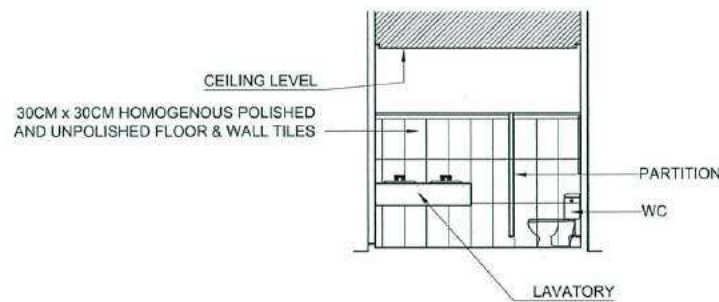


MENS TOILET
SECTION D-D
SCALE 1:100M

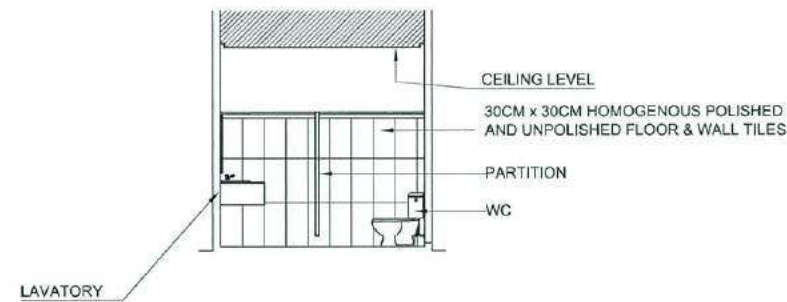


WOMENS TOILET
SECTION C-C
SCALE 1:100M

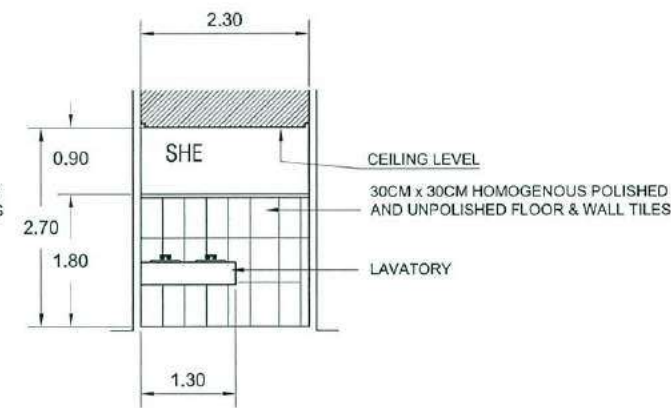

WOMENS TOILET
SECTION A-A
SCALE 1:100M

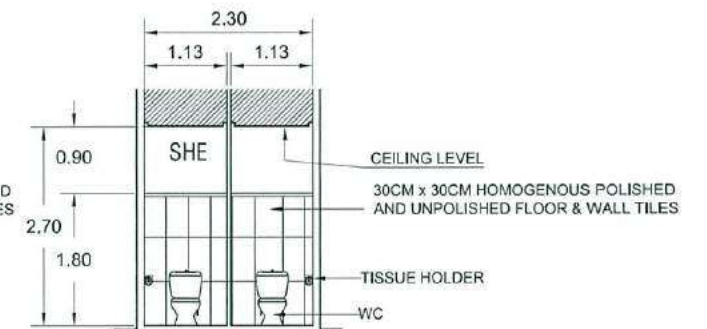


WOMENS TOILET
SECTION B-B
SCALE 1:100M

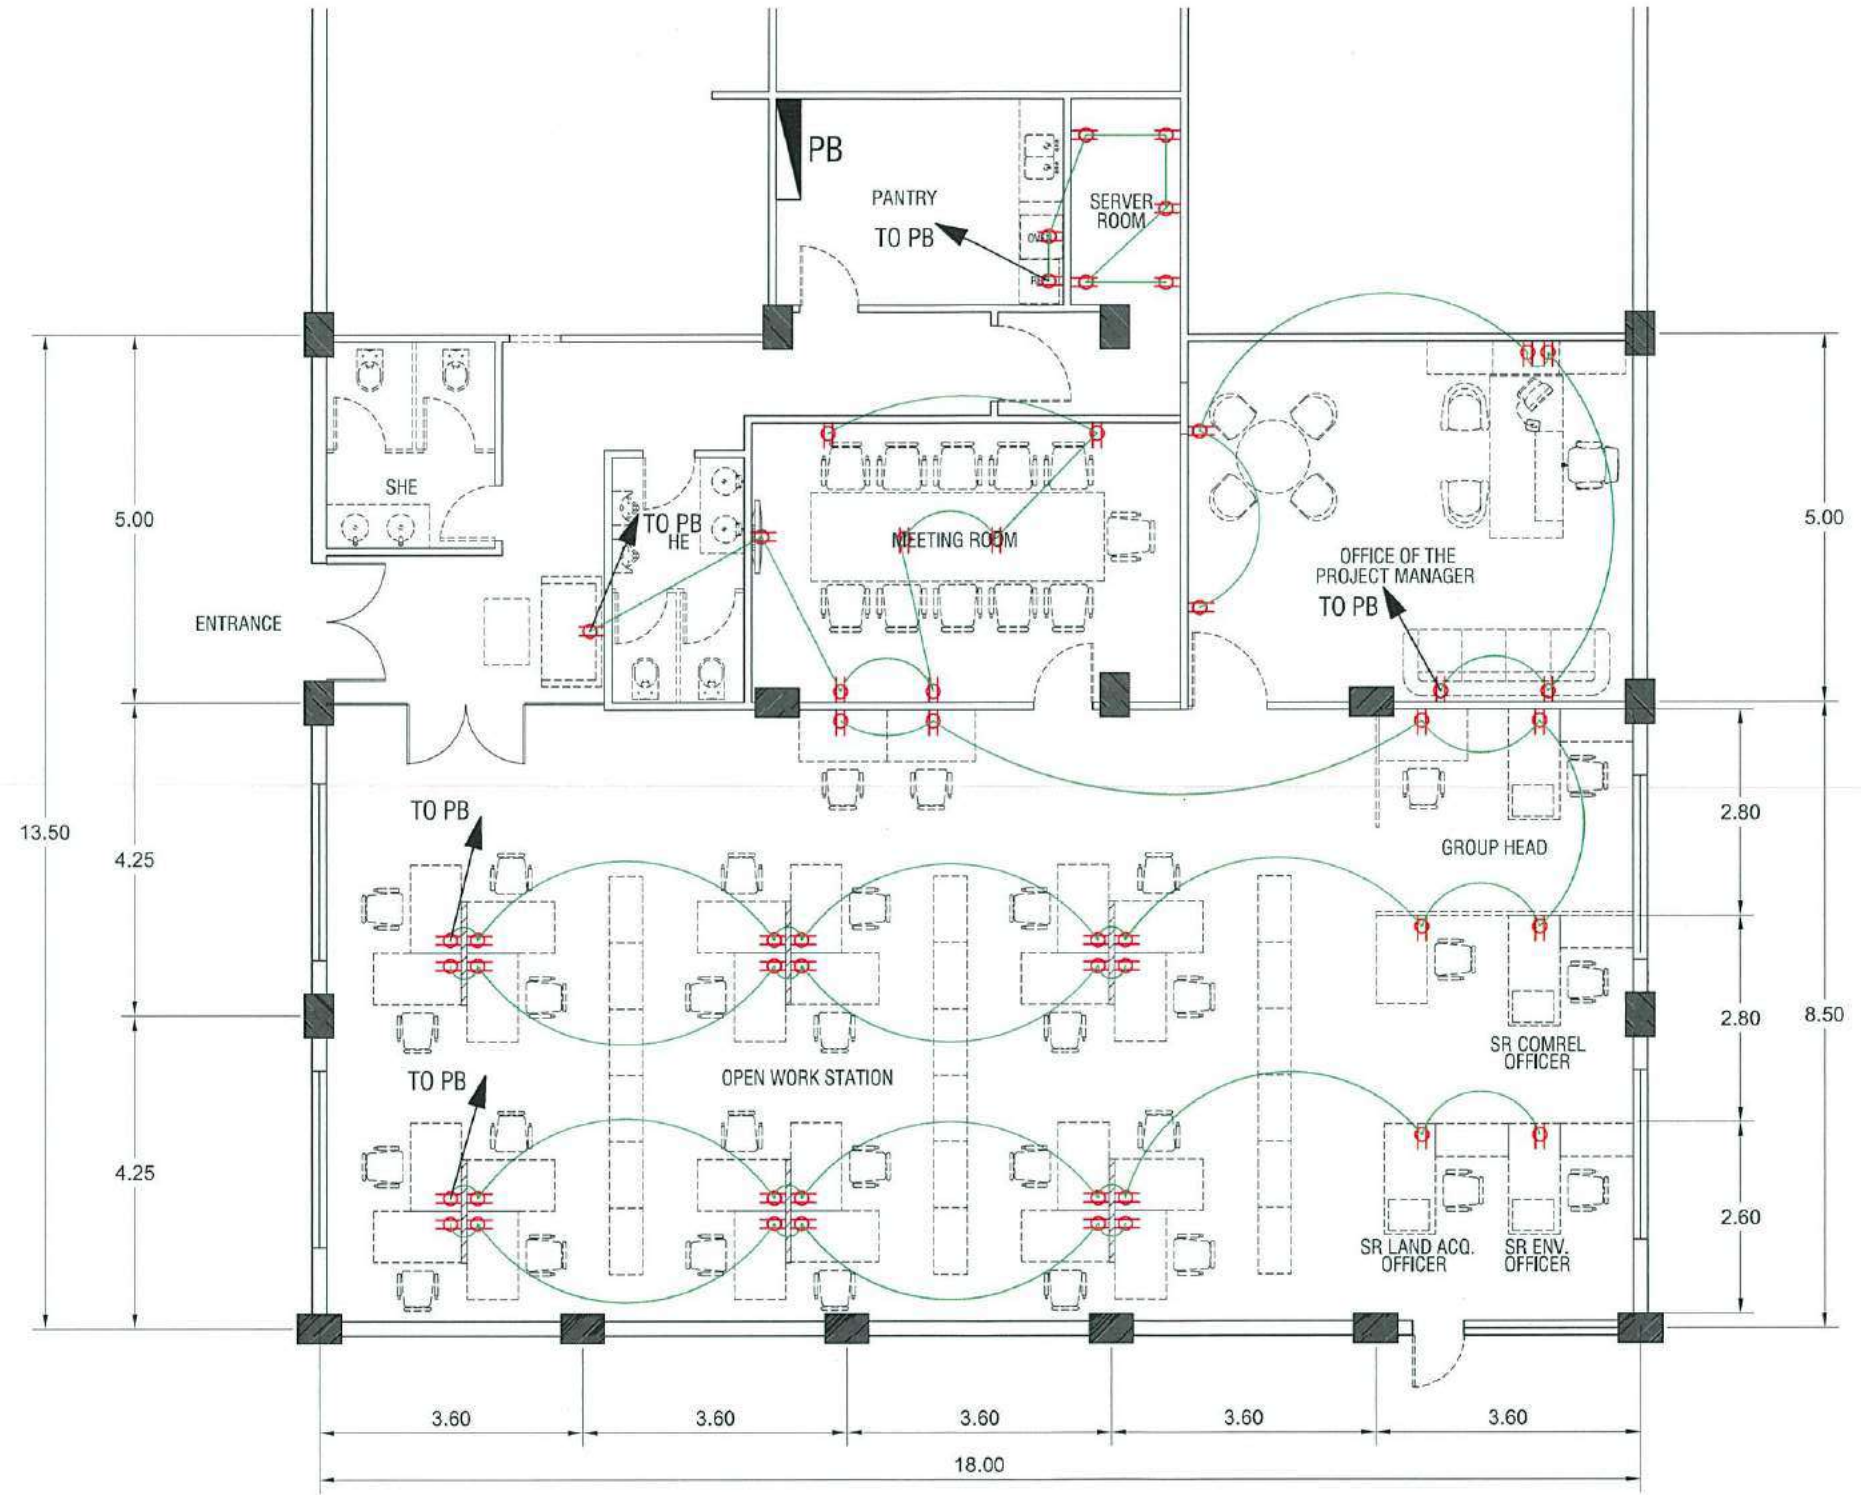

NOTE: 52 PCS. CONVENIENCE OUTLET DUPLEX POINTS
1 PC PANEL BOARD



BCDA Bases Conversion and Development Authority	PROJECT NAME	PREPARED BY	CHECKED & REVIEWED BY	RECOMMENDING APPROVAL	APPROVED BY	SHEET CONTENT	SHEET NO.
	PROPOSED SCRP OFFICE CLARK FREE PORT ZONE, PAMPANGA	AR. JUDENE G. LAGOY ARCHITECT, NCCPMO AR. ALBERT G. REYES CAD OPERATOR, SCRP	 REY S. LIM PROJECT MANAGER, SCRP	 AILEEN ANUNCIACION R. ZOSA EXECUTIVE VICE PRESIDENT	 VIVENCIO B. DIZON PRESIDENT AND CEO	POWER LAYOUT SCALE 1 : 100 M. DATE : 06-02-2020	E 01

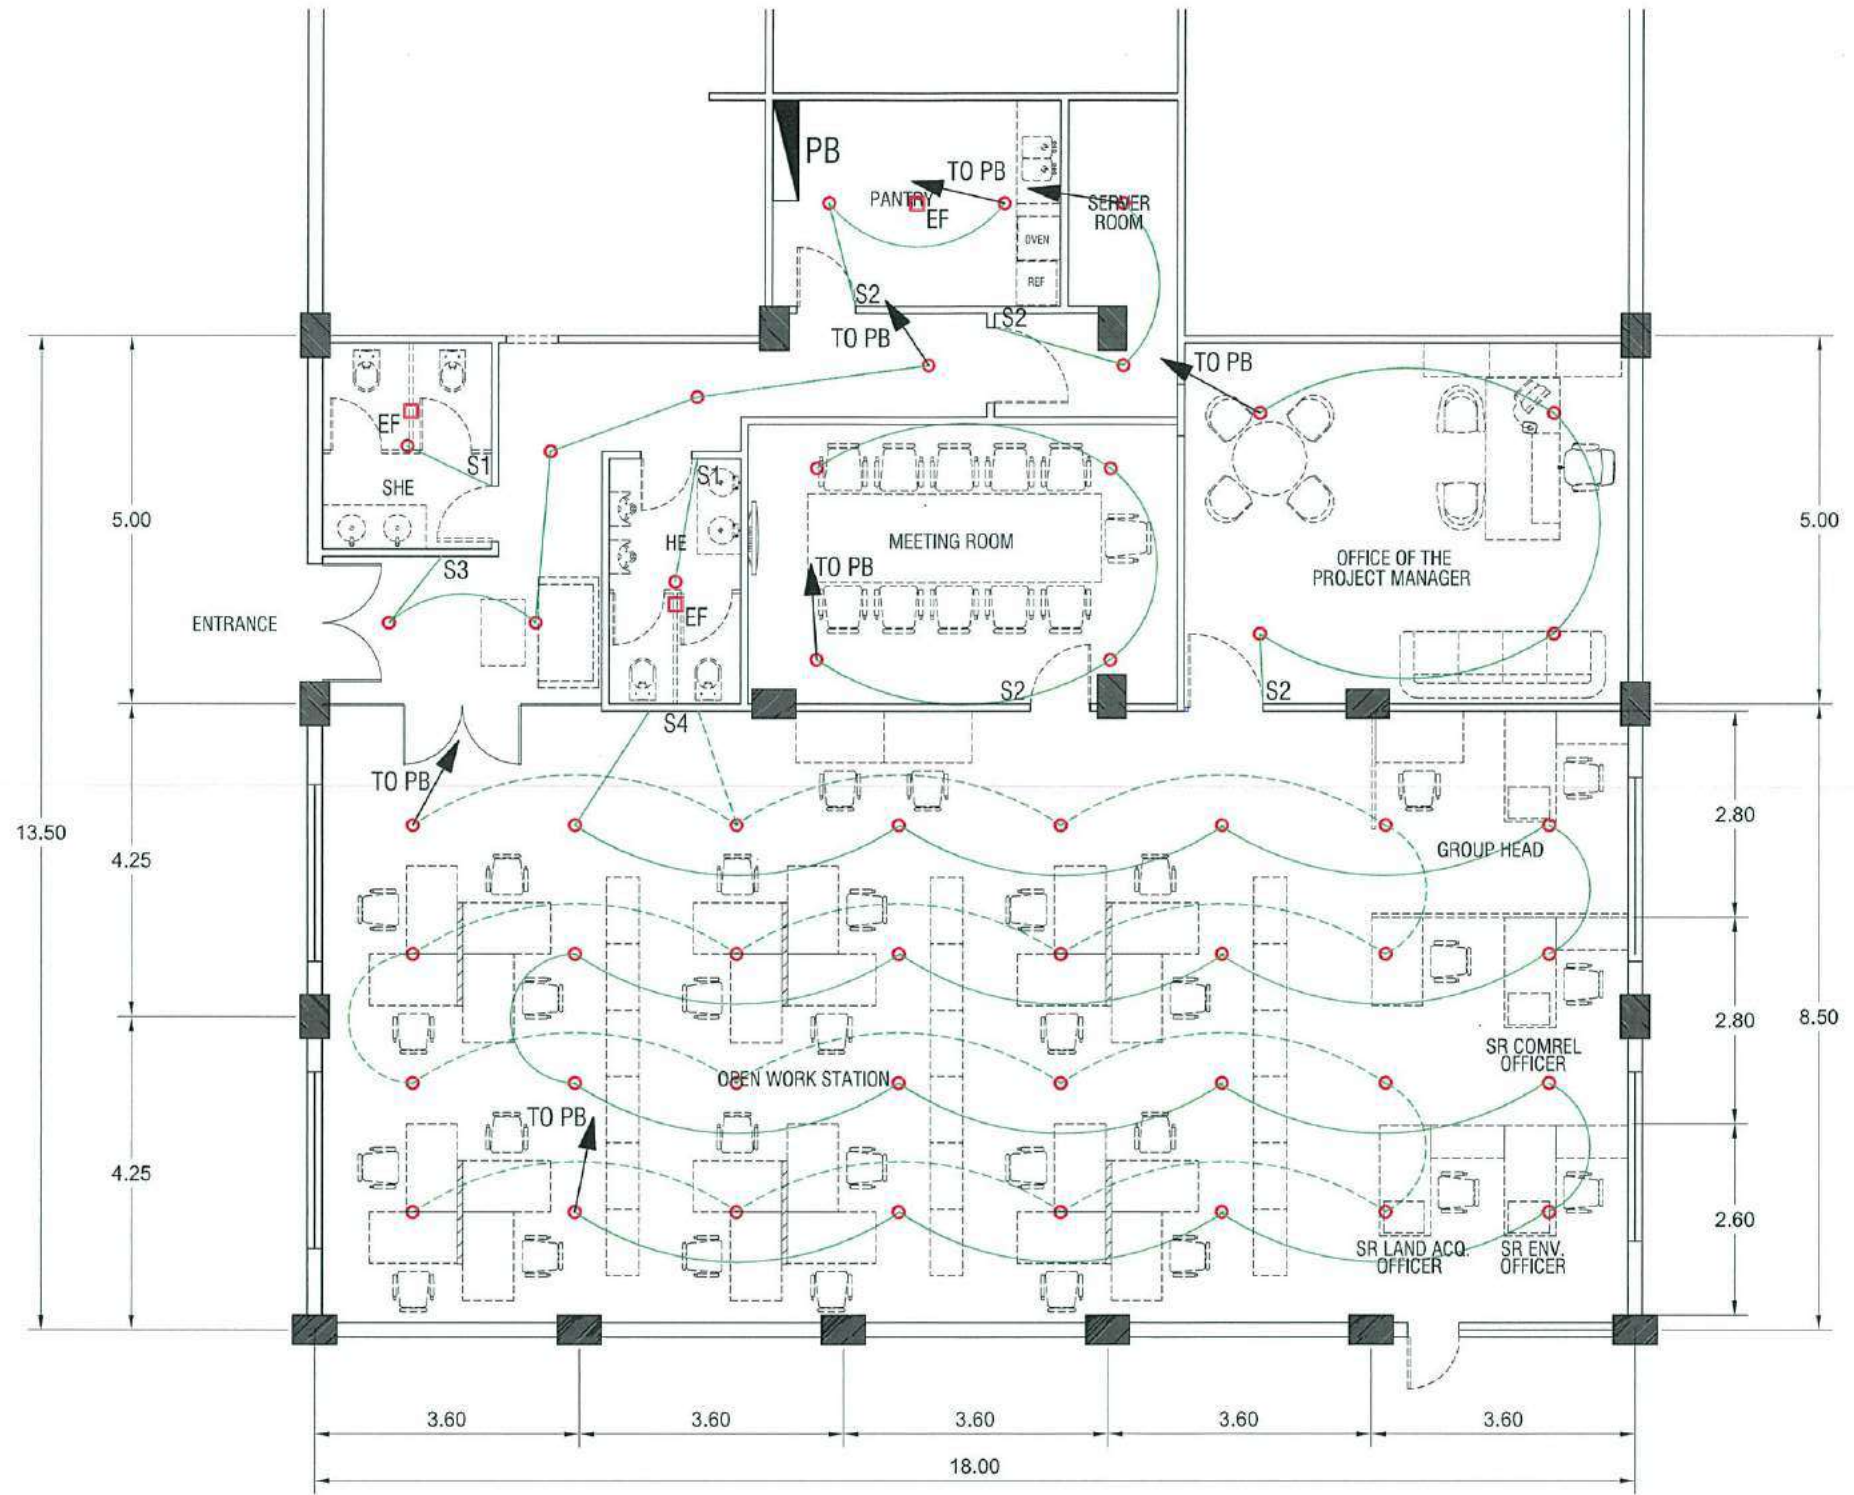




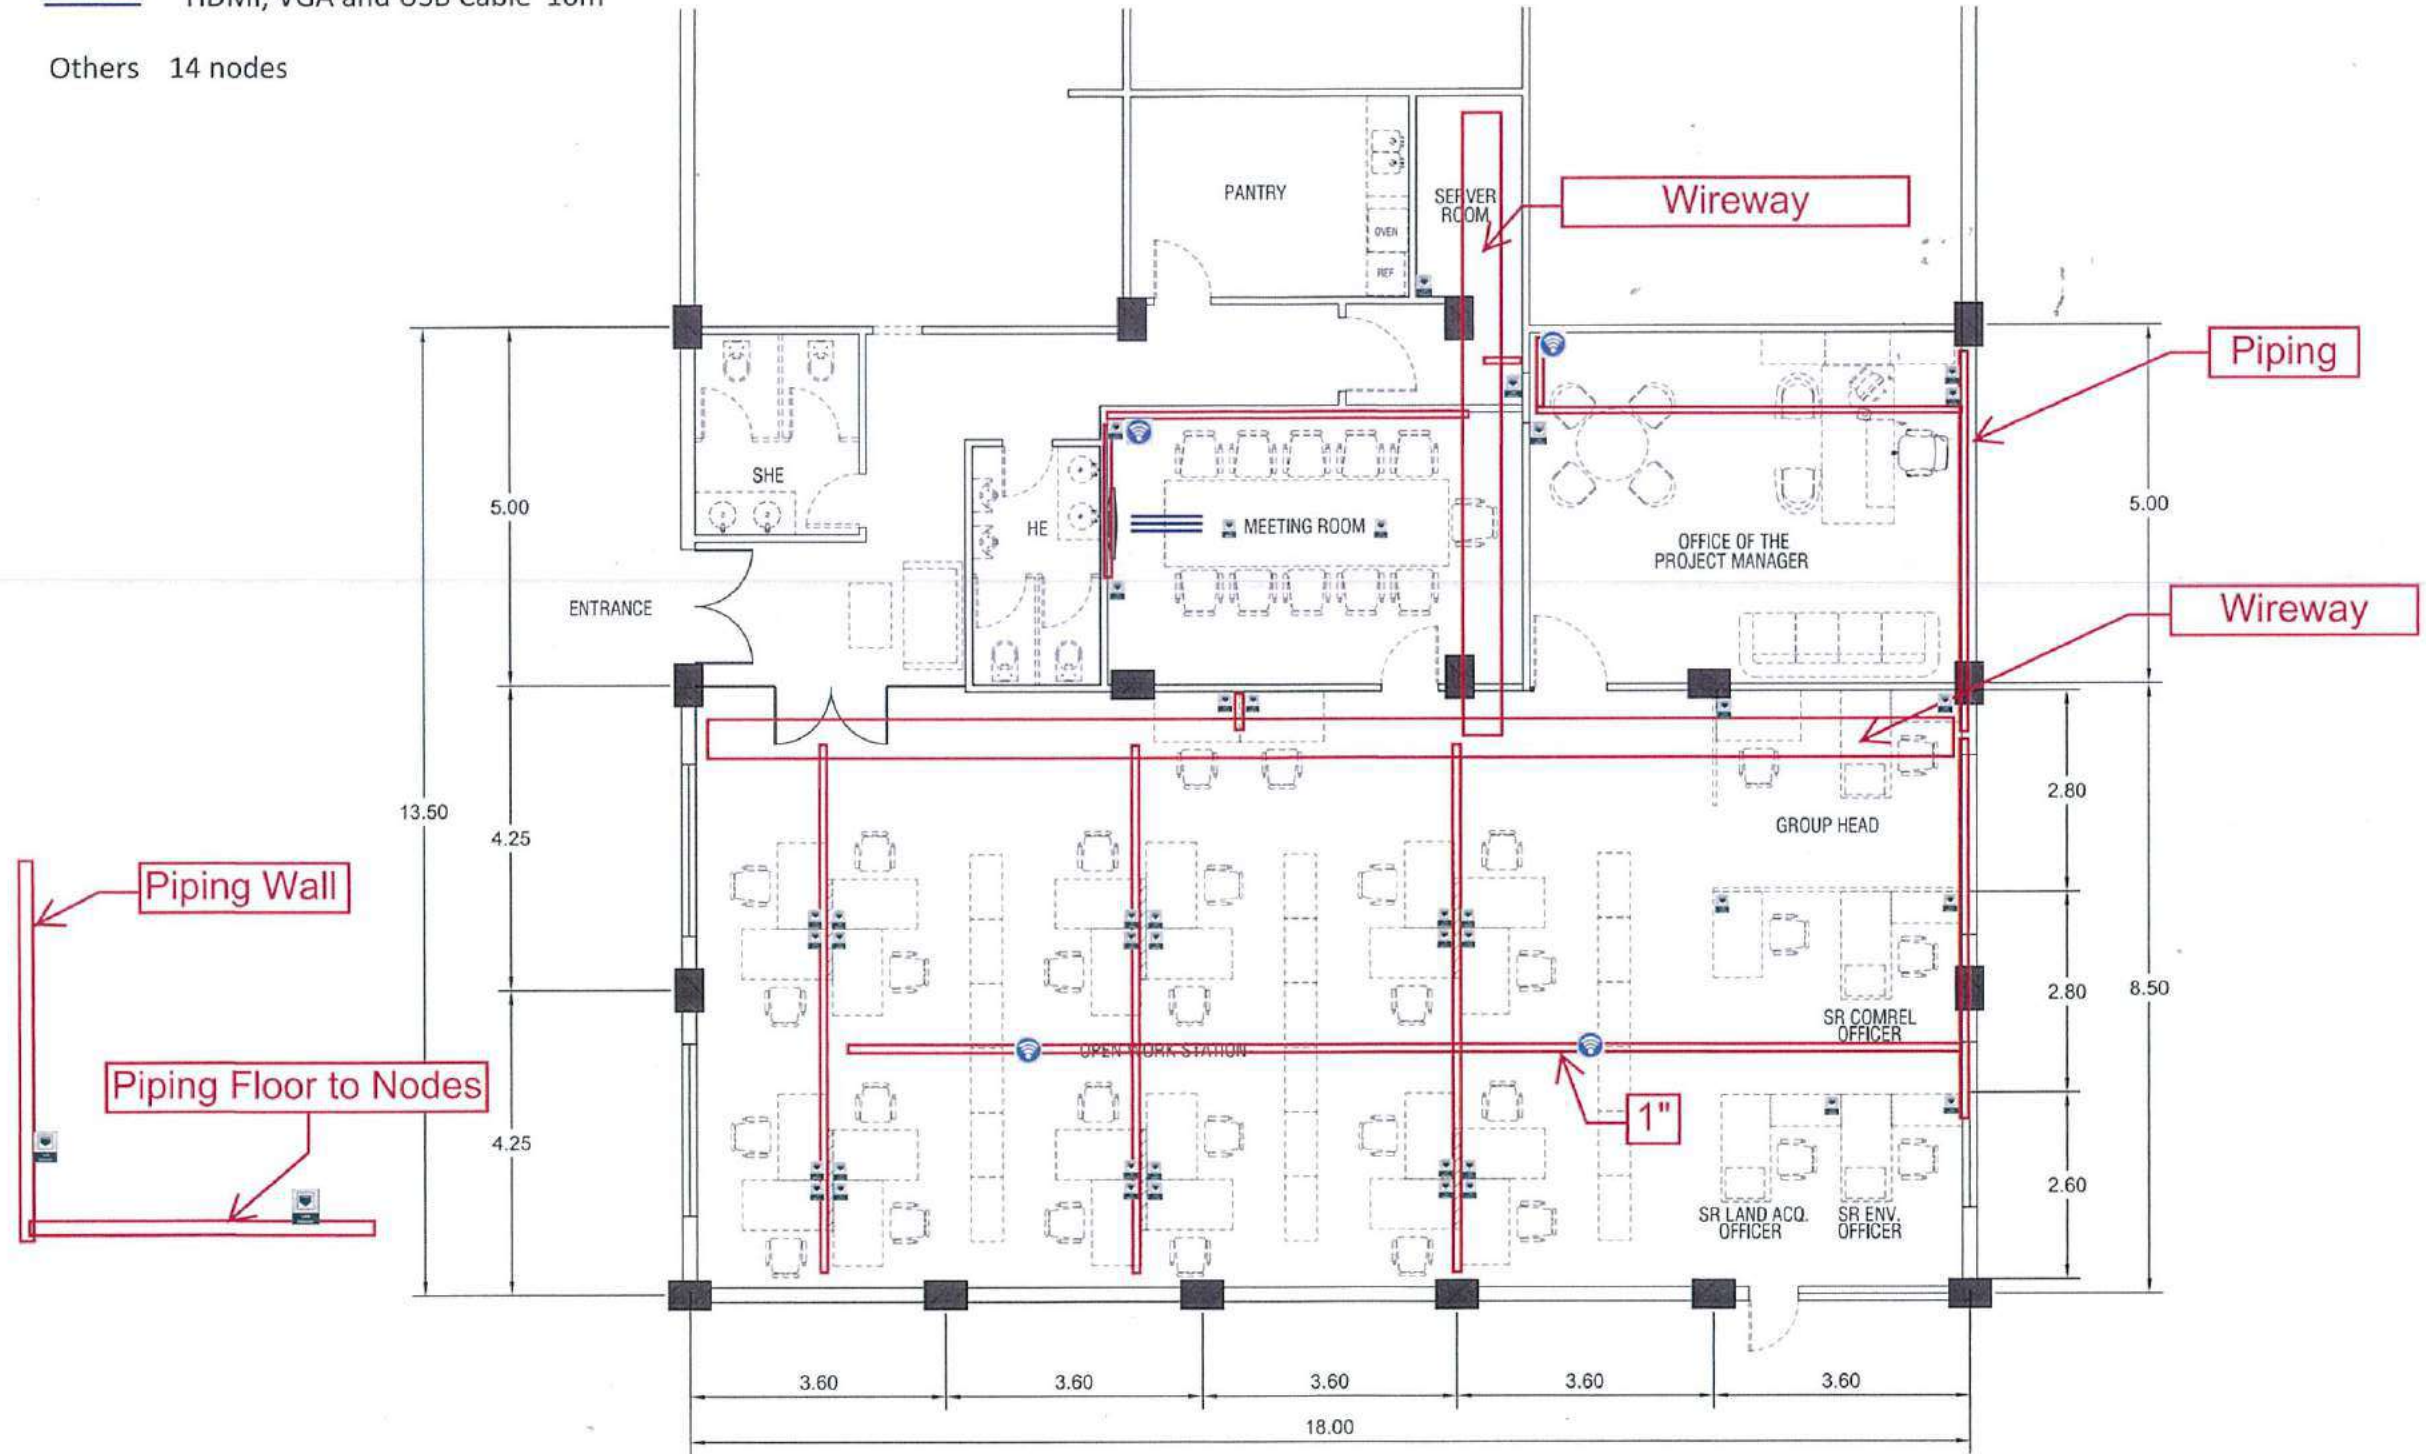
NOTE: 51 PCS. LIGHTING POINTS
 8 PCS. LIGHTING SWITCH
 3 PCS. EXHAUST FANS



PROJECT NAME PROPOSED SCRP OFFICE CLARK FREE PORT ZONE, PAMPANGA	PREPARED BY AR. JUDENE G. LAGOY ARCHITECT, NCC RMO AR. ALBERT G. REYES CAD OPERATOR, SCRP	CHECKED & REVIEWED BY REYS, LIM PROJECT MANAGER, SCRP	RECOMMENDING APPROVAL AILEEN ANUNCIACION R. ZOSA EXECUTIVE VICE PRESIDENT	APPROVED BY VIVENCIO B. DIZON PRESIDENT AND CEO	SHEET CONTENT		SHEET NO.
					LIGHTING LAYOUT		E
					SCALE 1 : 100 M.	DATE : 06-02-2020	02

PROVISION FOR NETWORK AND AUDIO/VIDEO STRUCTURED CABLING

-  LAN Port 41 nodes (wall, floor mount)
-  Access Point 4 nodes (ceiling mount)
-  HDMI, VGA and USB Cable 10m
- Others 14 nodes





- S PHOTO ELECTRIC SMOKE DETECTORS
- B FIRE ALARM BELL 6"
- H HEAT DETECTOR
- MCP MANUAL CALL POINT
- EOL END OF LINE RESISTOR



PROJECT NAME
PROPOSED SCRP OFFICE
CLARK FREE PORT ZONE, PAMPANGA

PREPARED BY
AR. JUDENE G. LAGOY
ARCHITECT, NCC PNO
AR. ALBERT G. REYES
CAD OPERATOR, SCRP


CHECKED & REVIEWED BY
REY S. LIM
PROJECT MANAGER, SCRP

RECOMMENDING APPROVAL
AILEEN ANUNCIACION R. ZOSA
EXECUTIVE VICE PRESIDENT

APPROVED BY
VIVENCIO B. DIZON
PRESIDENT AND CEO

SHEET CONTENT
FIRE DETECTION
AND ALARM SYSTEM LAYOUT
SCALE 1 : 100 M. DATE : 06-02-2020


SHEET NO.
E
04

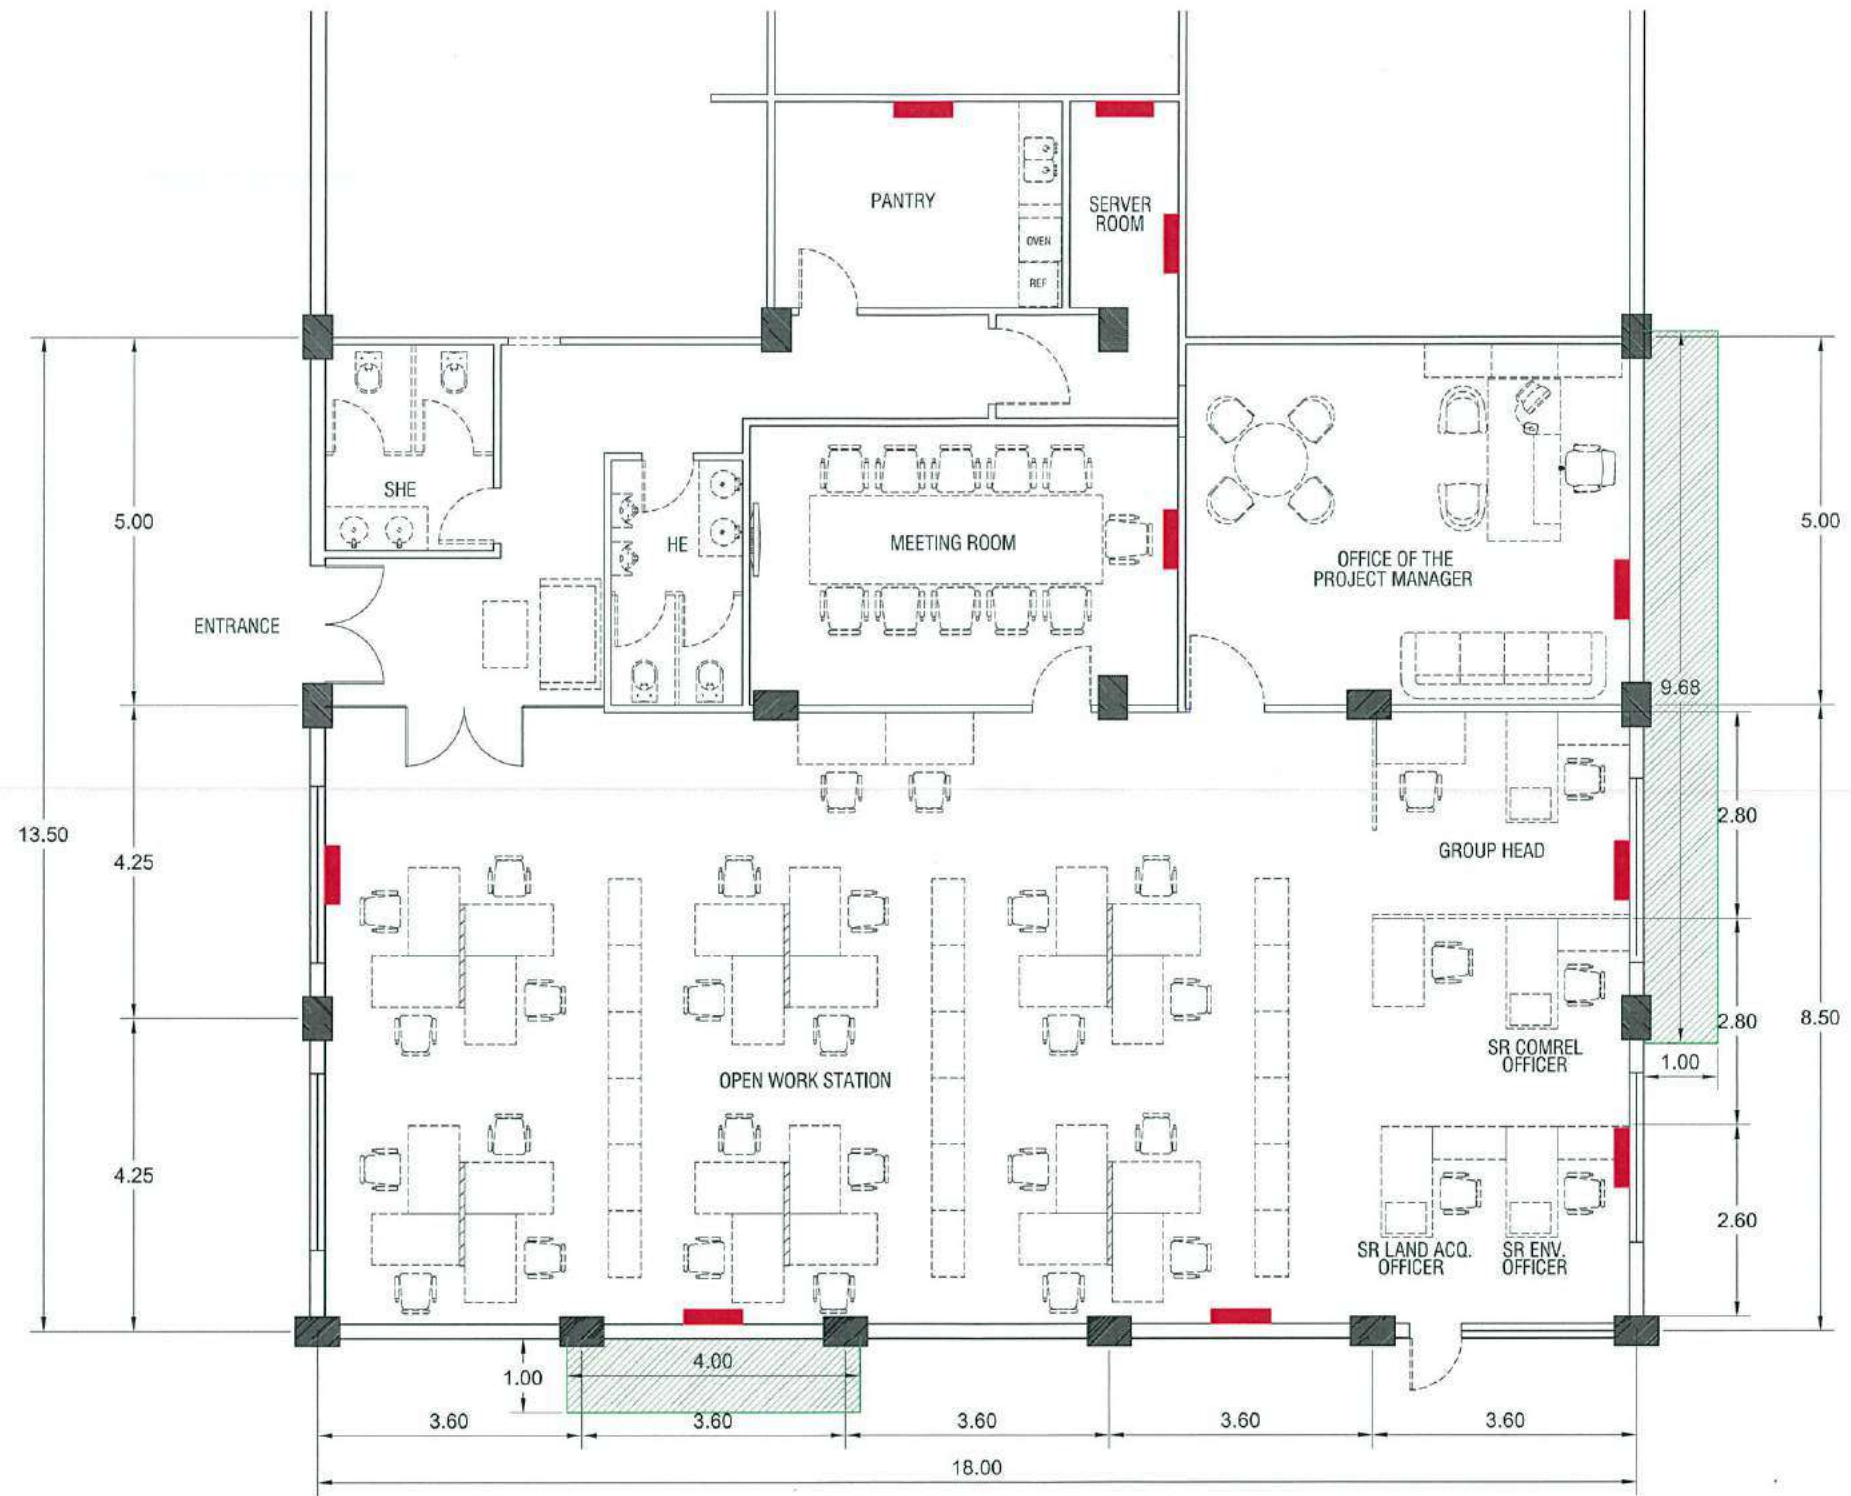

█ ACU INDOOR UNIT
 CONCRETE PLATFORM FOR ACU OUTDOOR UNIT
 A=13.70 sq.m THK=100mm



PROJECT NAME	PREPARED BY	CHECKED & REVIEWED BY	RECOMMENDING APPROVAL	APPROVED BY	SHEET CONTENT	SHEET NO.
PROPOSED SCRP OFFICE CLARK FREE PORT ZONE, PAMPANGA	AR. JUDENE G. LAGOY ARCHITECT, NCCTMO AR. ALBERT C. REYES CAD OPERATOR, SCRP	REY S. LIM PROJECT MANAGER, SCRP	AILEEN ANUNCIACION R. ZOS EXECUTIVE VICE PRESIDENT	VIVENCIO B. DIZON PRESIDENT AND CEO	ACU LAYOUT SCALE 1 : 100 M. DATE : 06-02-2020	E 05

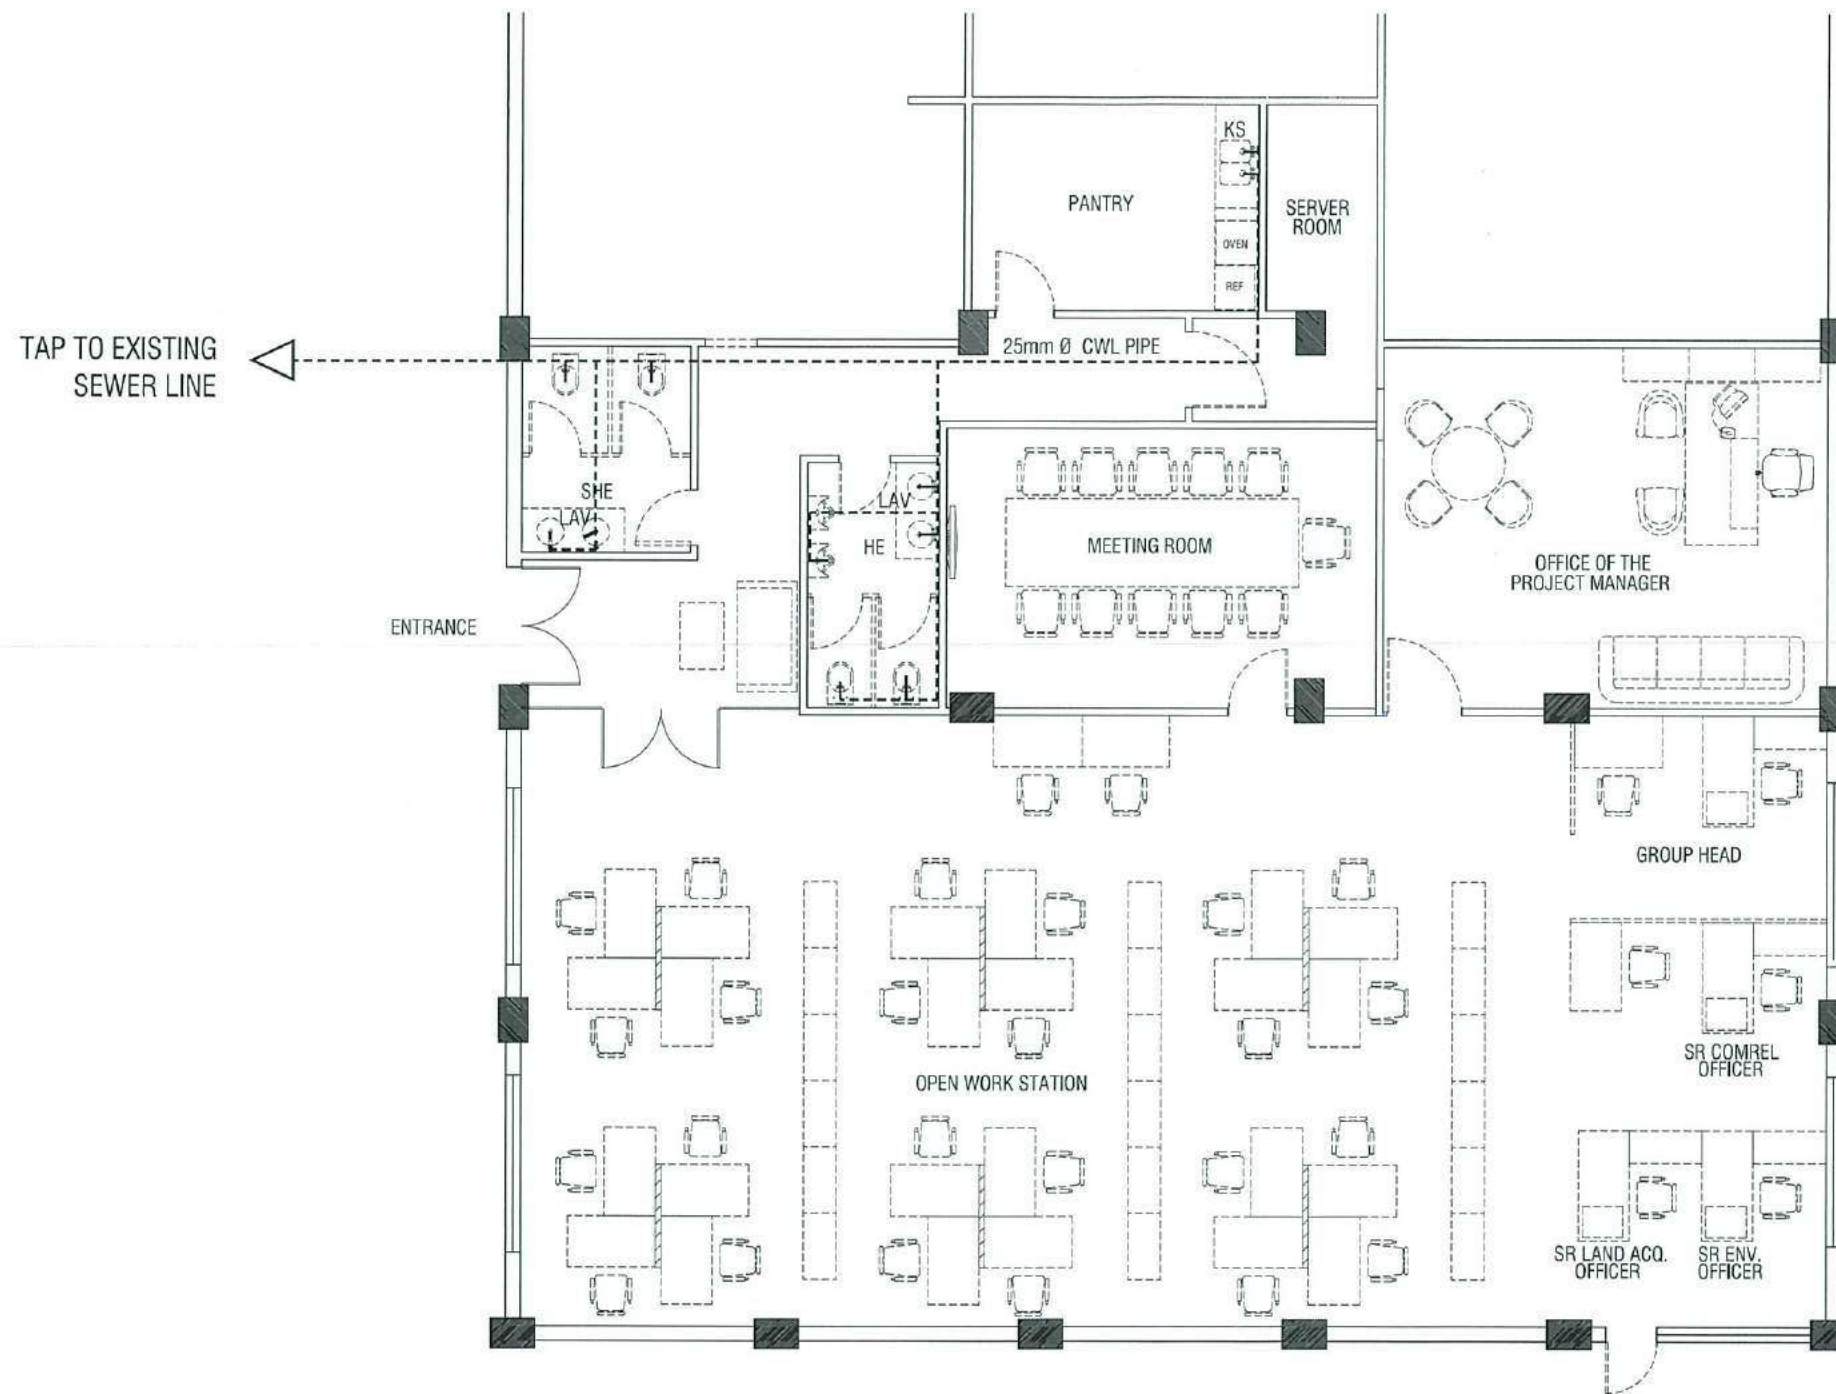


FLOOR SHOULD HAVE A WATER PROOFING,
DRAIN WITH CONTAINMENT. SINK WASTE DRAIN
SHALL ALSO HAVE AN IN-LINE GREASE TRAP.

FLOOR DRAIN MUST BE 50mmØ
WITH 100mm STRAINER FOR TOILETS.

TAP TO EXISTING
SEWER LINE

FLOOR DRAIN MUST BE 50mmØ
WITH 100mm STRAINER FOR TOILETS.

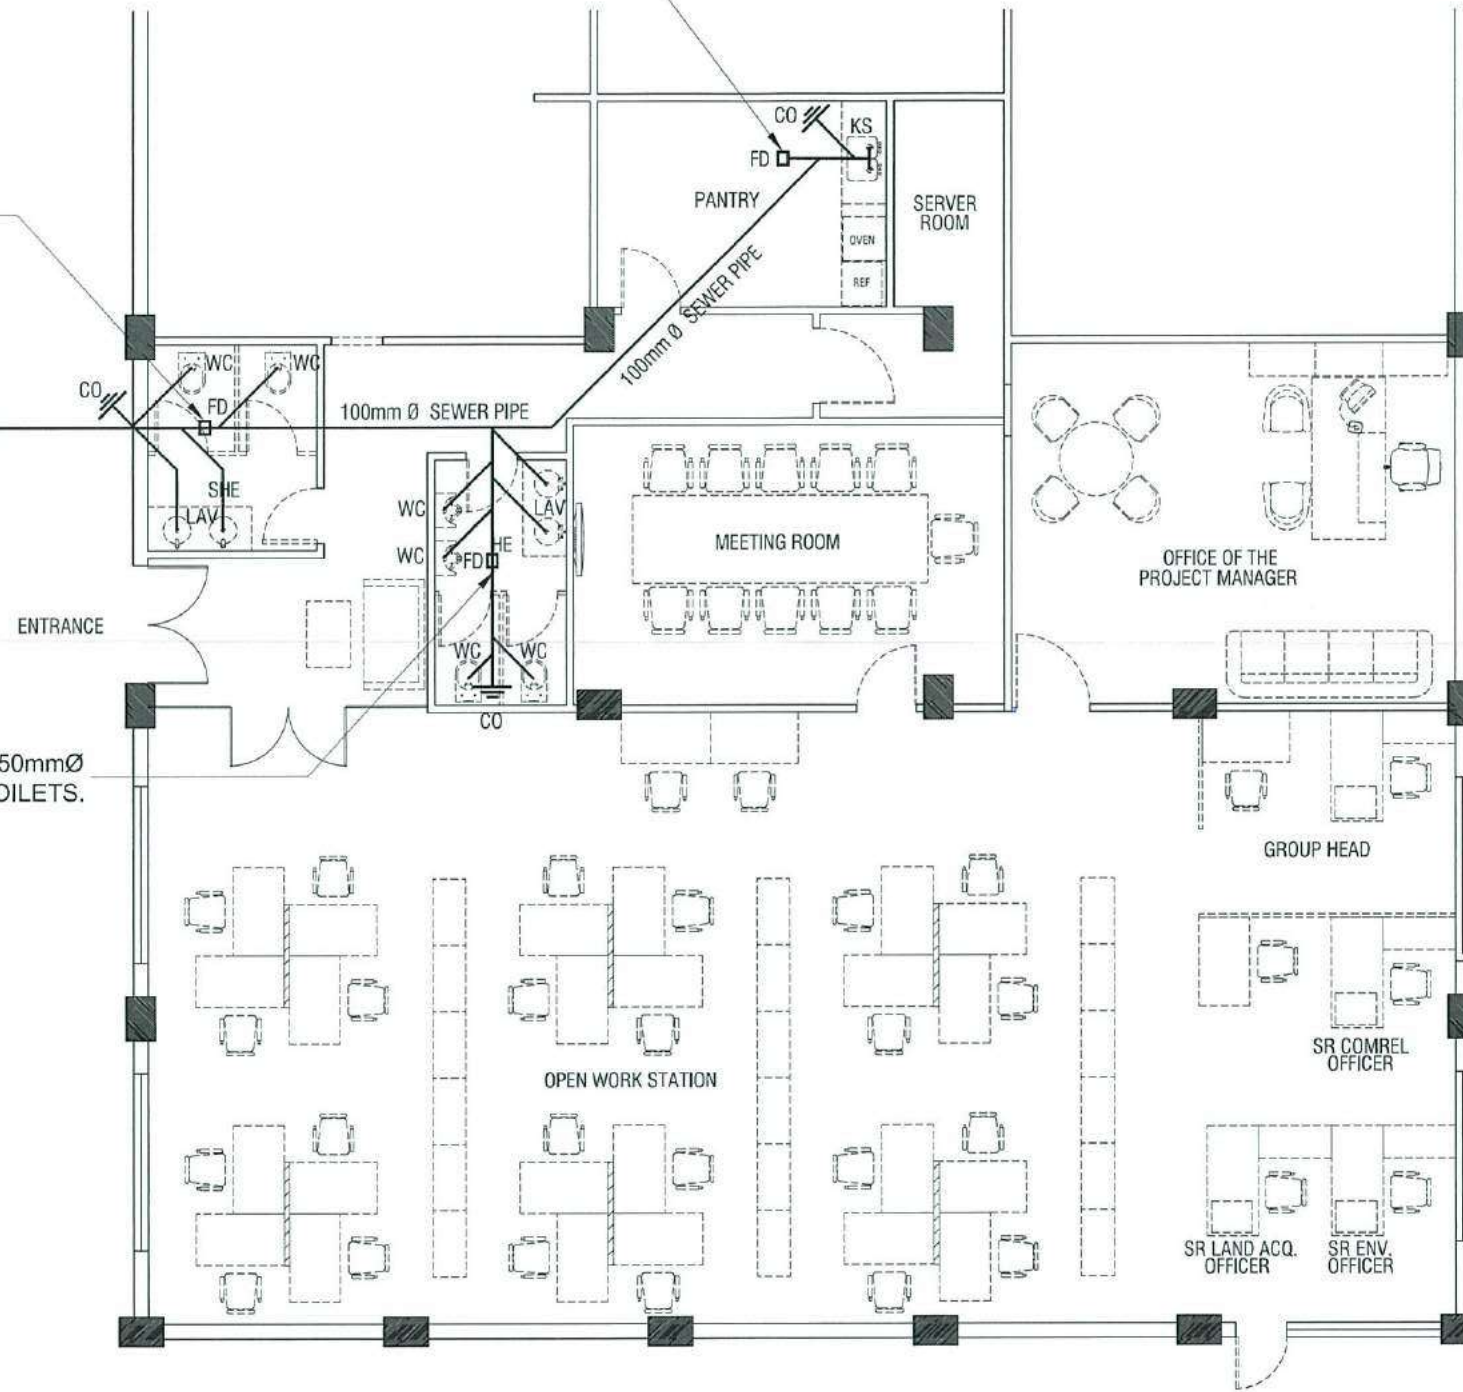

	PROJECT NAME	PREPARED BY	CHECKED & REVIEWED BY	RECOMMENDING APPROVAL	APPROVED BY	SHEET CONTENT	SHEET NO.
	PROPOSED SCRCP OFFICE CLARK FREE PORT ZONE, PAMPANGA	AR. JUDENE G. LAGOY ARCHITECT, NCC PMO AR. ALBERT G. REYES CAD OPERATOR, SCRCP	REYES, LIM PROJECT MANAGER, SCRCP	AILEEN ANUNCIACION R. ZOSA EXECUTIVE VICE PRESIDENT	VIVENCIO B. DIZON PRESIDENT AND CEO	SANITARY PIPE PLAN SCALE 1:100 M. DATE: 06-02-2020	P 02